


IMPROVEMENT DRAWINGS FOR  
**BOLINAS PATHWAY**  
BOLINAS, MARIN COUNTY CA  
OVERLOOK DR, MESA RD & OLEMA BOLINAS RD  
BCPUD PROPERTY, APN 193-030-38

FEBRUARY 2024

OWNER: BOLINAS COMMUNITY PUBLIC UTILITY DISTRICT  
270 ELM RD, P.O. BOX 390  
BOLINAS, CA 94924  
PH: (415) 868-1224  
FAX: (415) 868-9501

CIVIL ENGINEER: BKF ENGINEERS  
200 4TH ST, STE. 300  
SANTA ROSA, CA 95401  
PH: (707) 583-8500  
FAX: (707) 583-8539

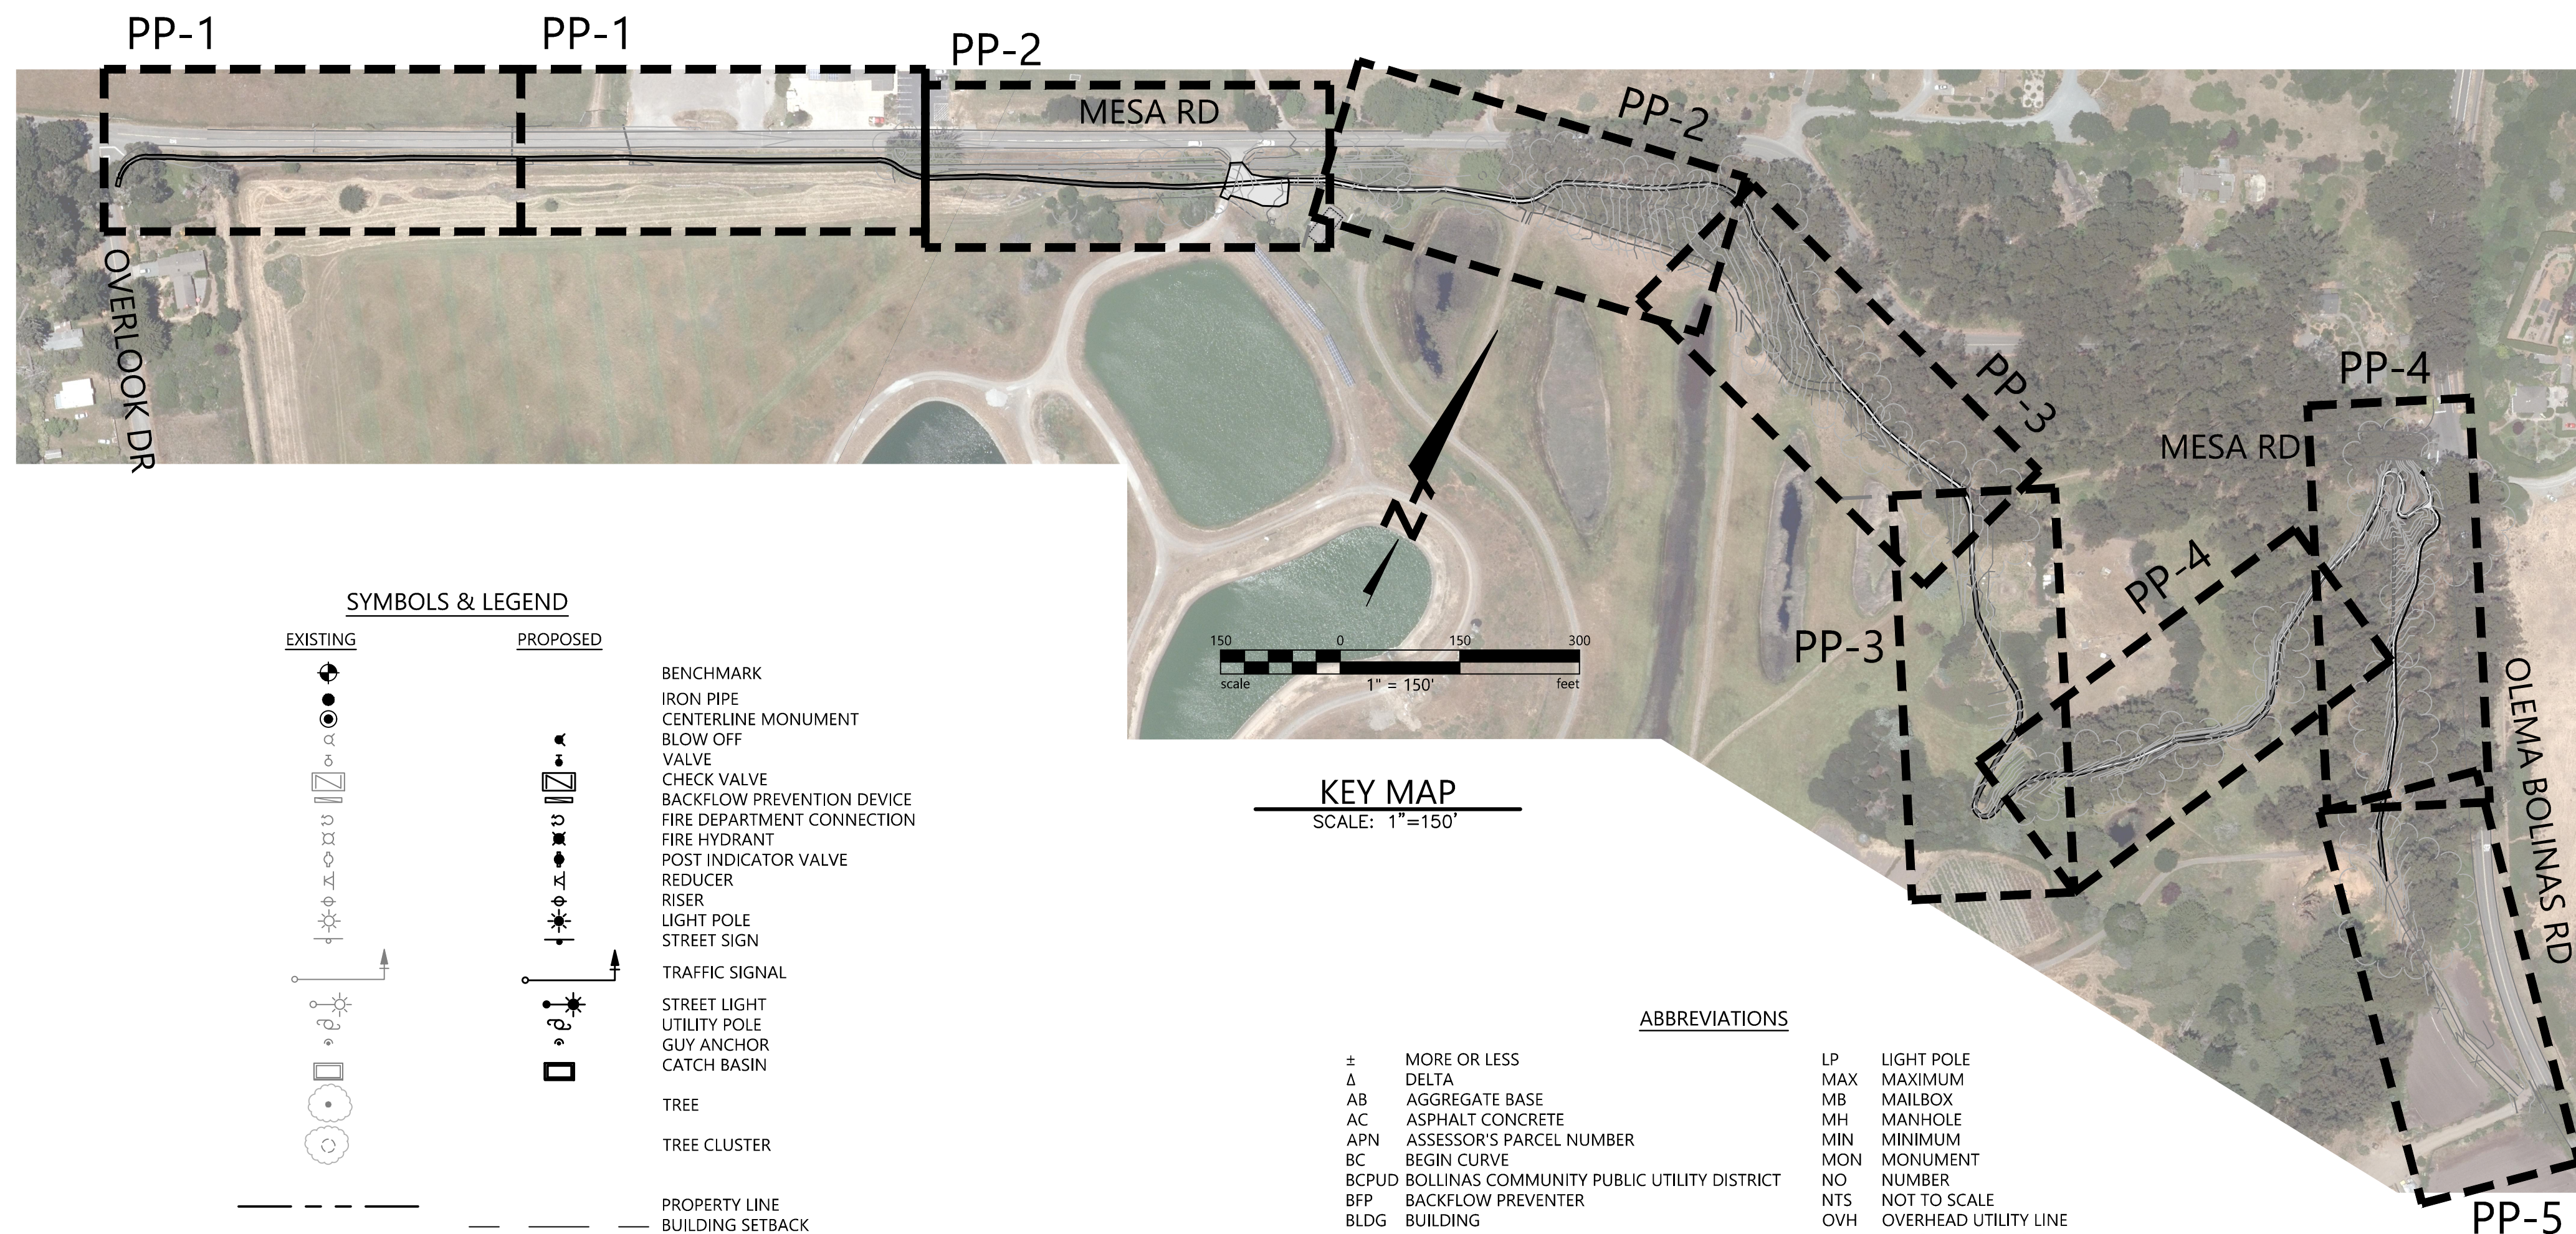

**INDEX OF DRAWINGS**

1. COVER SHEET
2. TYPICAL SECTIONS
3. PATHWAY PLAN & PROFILE (STA 0+00 - STA 10+25)
4. PATHWAY PLAN & PROFILE (STA 10+25 - STA 15+25)
5. PATHWAY PLAN & PROFILE (STA 15+25 - STA 20+75)
6. PATHWAY PLAN & PROFILE (STA 20+75 - STA 26+00)
7. PATHWAY PLAN & PROFILE (STA 26+00 - STA 31+25)
8. PATHWAY PLAN & PROFILE (STA 31+25 - STA 36+00)
9. PATHWAY PLAN & PROFILE (STA 36+00 - STA 41+75)
10. PATHWAY PLAN & PROFILE (STA 41+75 - STA 43+13)


**SYMBOLS & LEGEND**

EXISTING	PROPOSED	
		BENCHMARK
		IRON PIPE
		CENTERLINE MONUMENT
		BLOW OFF
		VALVE
		CHECK VALVE
		BACKFLOW PREVENTION DEVICE
		FIRE DEPARTMENT CONNECTION
		FIRE HYDRANT
		POST INDICATOR VALVE
		REDUCER
		RISER
		LIGHT POLE
		STREET SIGN
		TRAFFIC SIGNAL
		STREET LIGHT
		UTILITY POLE
		GUY ANCHOR
		CATCH BASIN
		TREE
		TREE CLUSTER
		PROPERTY LINE
		BUILDING SETBACK
		EASEMENT
		CENTERLINE
		GRADE BREAK
		FLOW LINE
		FENCE
		TREE PROTECTION FENCE
		SANITARY SEWER
		STORM DRAIN
		WATER
		OVERHEAD UTILITY LINE
		UNDERGROUND UTILITY LINE
		UNDERGROUND ELECTRIC LINE
		UNDERGROUND GAS LINE
		UNDERGROUND TELECOM LINE
		ASPHALT
		ASPHALT GRIND & OVERLAY
		CONCRETE
		DETECTABLE WARNING
		VALLEY GUTTER
		BIORETENTION AREA
		INVERT AT CLEANOUT
		KEYNOTE
		DETAIL IDENTIFICATION SHEET WHERE DETAIL IS SHOWN
		CROSS SECTION IDENTIFICATION SHEET WHERE CROSS SECTION IS SHOWN


**KEY MAP**  
SCALE: 1"=150'

**ABBREVIATIONS**

±	MORE OR LESS	LP	LIGHT POLE
Δ	DELTA	MAX	MAXIMUM
AB	AGGREGATE BASE	MB	MAILBOX
AC	ASPHALT CONCRETE	MH	MANHOLE
APN	ASSESSOR'S PARCEL NUMBER	MIN	MINIMUM
BC	BEGIN CURVE	MON	MONUMENT
BCPUD	BOLINAS COMMUNITY PUBLIC UTILITY DISTRICT	NO	NUMBER
BFP	BACKFLOW PREVENTER	NTS	NOT TO SCALE
BLDG	BUILDING	OVH	OVERHEAD UTILITY LINE
BLRD	BOLLARD	OR	OFFICIAL RECORDS
BM	BENCHMARK	PG&E	PACIFIC GAS & ELECTRIC
BO	BLOWOFF	PIV	POST INDICATOR VALVE
CB	CATCH BASIN	PL	PROPERTY LINE
CC	POINT OF COMPOUND CURVE	PUE	PUBLIC UTILITY EASEMENT
CL	CENTERLINE	PVI	POINT OF VERTICAL INTERSECTION
CL2	CLASS II	R	RADIUS
CO	CLEAN OUT	RC	POINT OF REVERSE CURVE
CONC	CONCRETE	RSPR	RIPRAP ROCK SLOPE PROTECTION
CY	CUBIC YARD	RTWL	RETAINING WALL
DDC	DOUBLE DETECTOR CHECK	R/W	RIGHT OF WAY
DI	DROP INLET	S=	SLOPE
DIA	DIAMETER	SD	STORM DRAIN
DN	DOCUMENT NUMBER	SDCO	STORM DRAIN CLEAN OUT
DW	DRIVEWAY	SDMH	STORM DRAIN MANHOLE
DYL	DOUBLE YELLOW LINE	SF	SQUARE FEET
E	ELECTRIC	SL	STREETLIGHT
EG	EXISTING GROUND	SS	SANITARY SEWER
ELEV	ELEVATION	SSCO	SANITARY SEWER CLEAN OUT
EP	EDGE OF PAVEMENT	SSMH	SANITARY SEWER MANHOLE
ER	EDGE OF ROAD	STA	STATION
ESMT	EASEMENT	STD	STANDARD
EX	EXISTING	TB	TOP OF BOX
FDC	FIRE DEPARTMENT CONNECTION	TC	TOP FACE OF CURB
FG	FINISHED GRADE	TEL	TELECOMMUNICATION LINE
FH	FIRE HYDRANT	TF	TRANSFORMER
FL	SURFACE FLOWLINE	TG	TOP OF GRATE
FT	FOOT	TW	TOP OF WALL
G	GAS	TYP	TYPICAL
GB	GRADE BREAK	UB	UTILITY BOX
GI	GRATE INLET	UP	UTILITY POLE
GM	GAS METER	UT	UNDERGROUND UTILITY LINE
HB	HOSE BIB	VC	VERTICAL CURVE
HORZ	HORIZONTAL	VERT	VERTICAL
HT	HEIGHT	VLT	VULT
INV	BOTTOM INSIDE OF PIPE	W	WATER
IP	IRON PIPE	WL	WHITE LINE
IR	IRRIGATION	WM	WATER METER
L	LENGTH	WS	WATER SERVICE

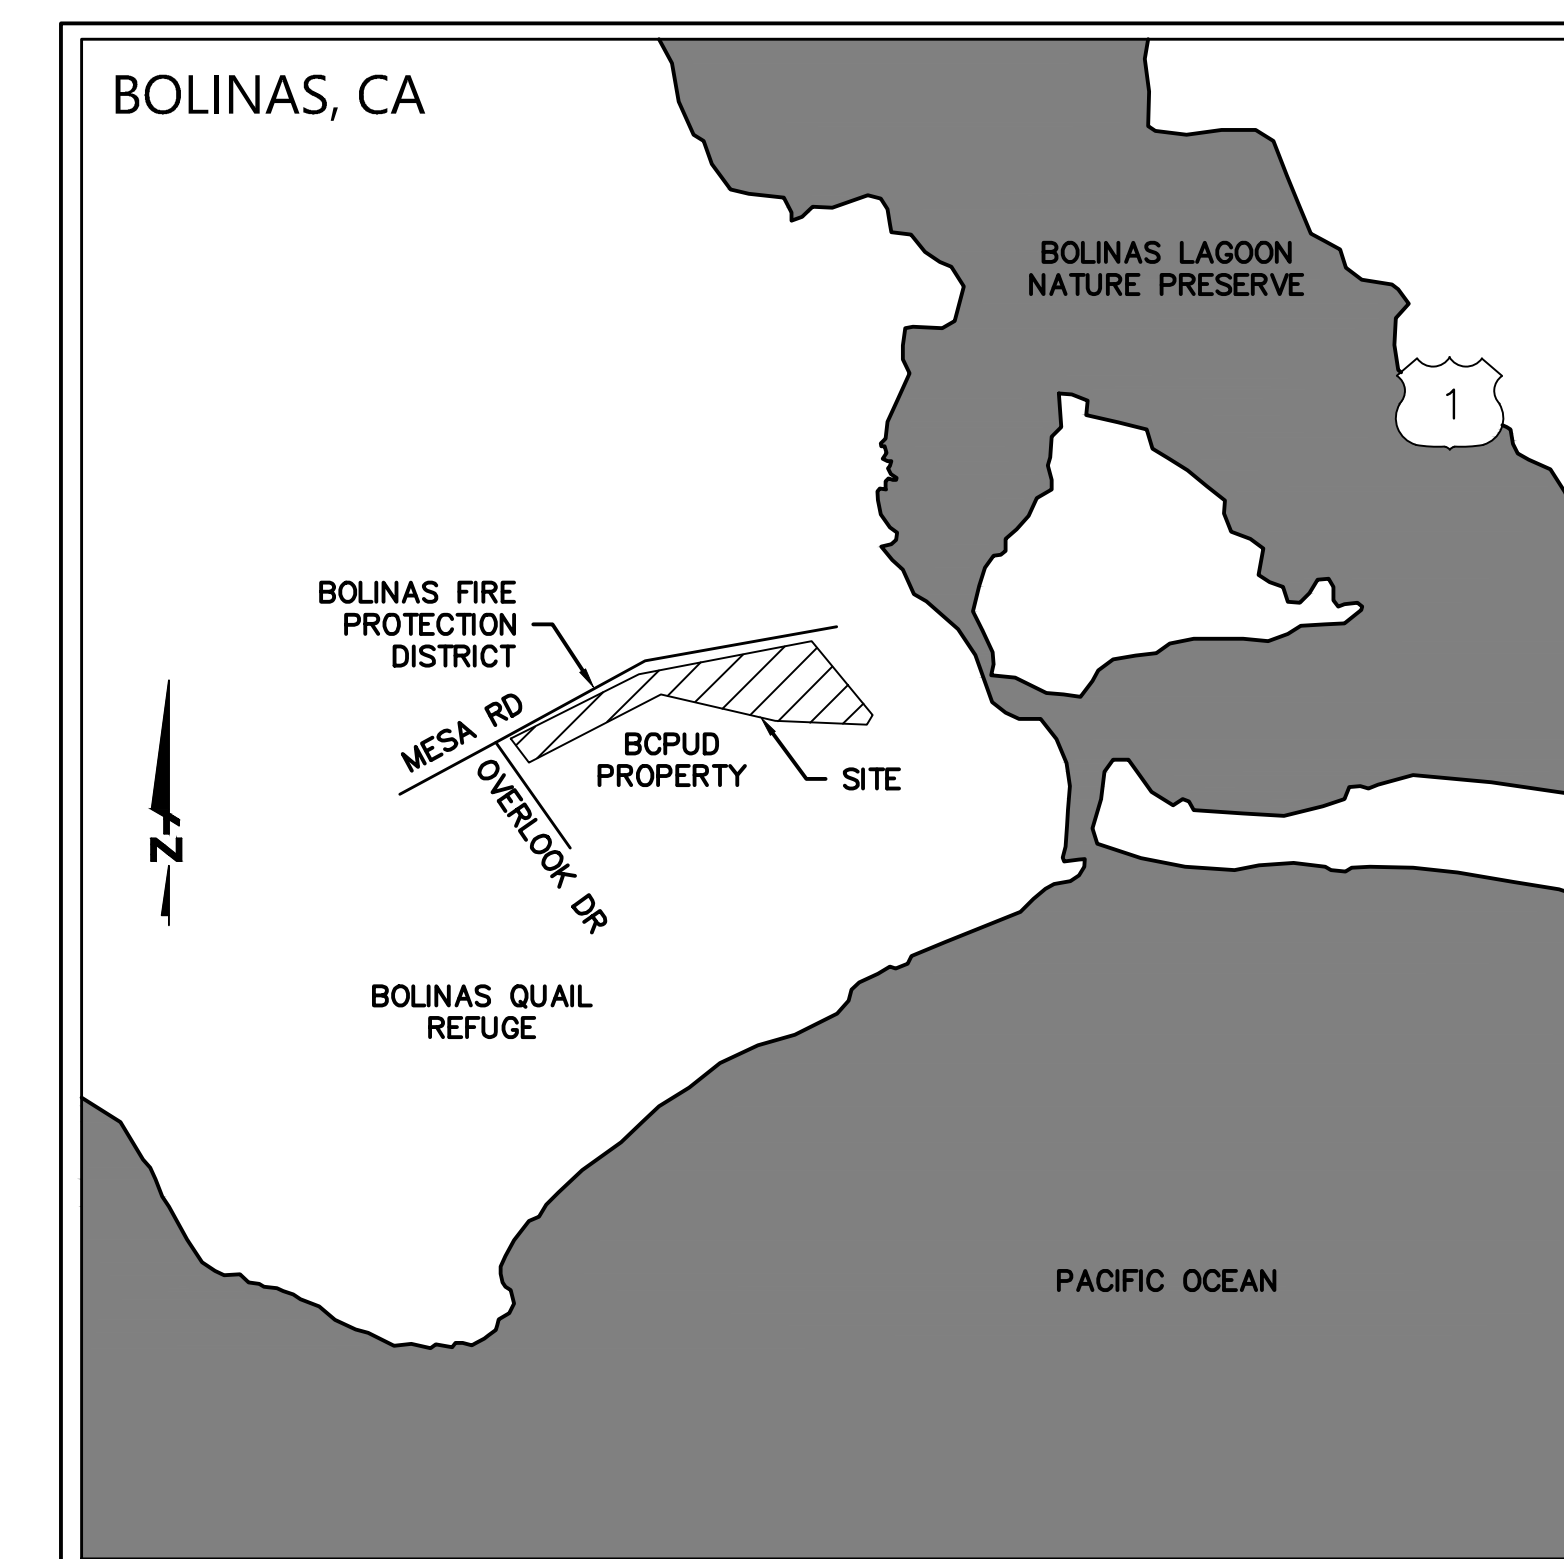

**VICINITY MAP**  
NOT TO SCALE

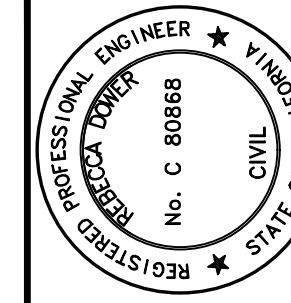

**PRELIMINARY**  
NOT FOR CONSTRUCTION

DATE: 02/14/2024

REBECCA DOWER

**BKF ENGINEERS**  
200 4TH STREET  
SUITE 300  
SANTA ROSA, CA 95401  
PH: (707) 583-8500  
WWW.BKF.COM



**BOLINAS PATHWAY**  
APN 193-030-38  
MESA RD & OLEMA BOLINAS RD, BOLINAS, CA

**COVER SHEET**

Revisions

Date: FEB 2024

Scale: AS SHOWN

Design: IC

Drawn: AS

Approved: BD


Job No: 20220375

Drawing Number:


**CS-1**

1 OF 10




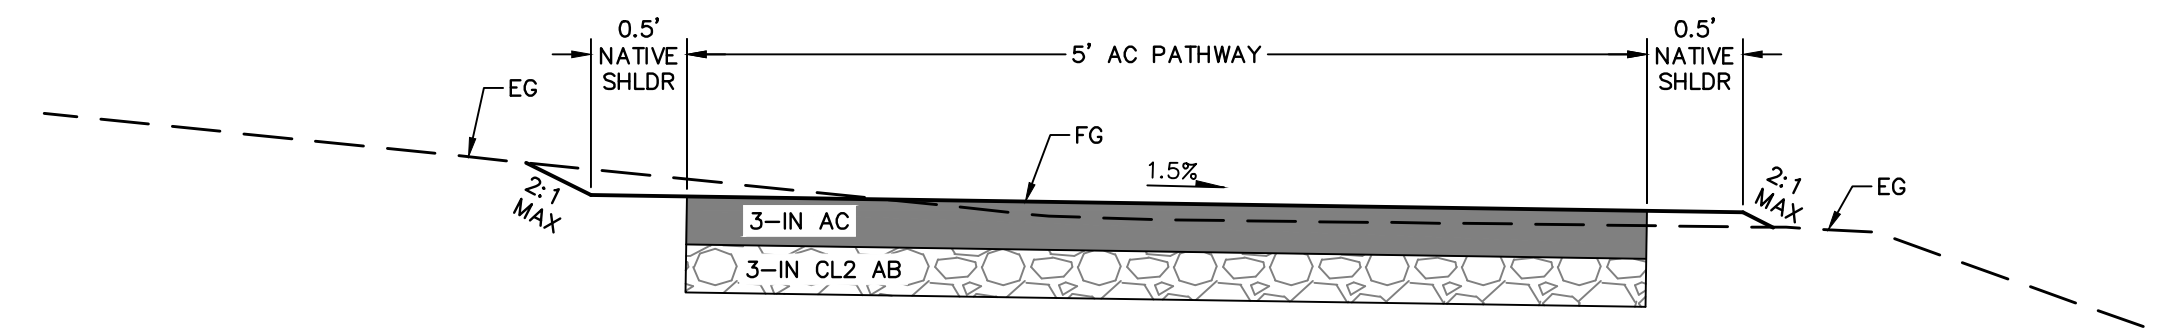


1  
-  
**TYPICAL PATHWAY SECTION 1**  
NTS PATHWAY BEG - STA 10+25

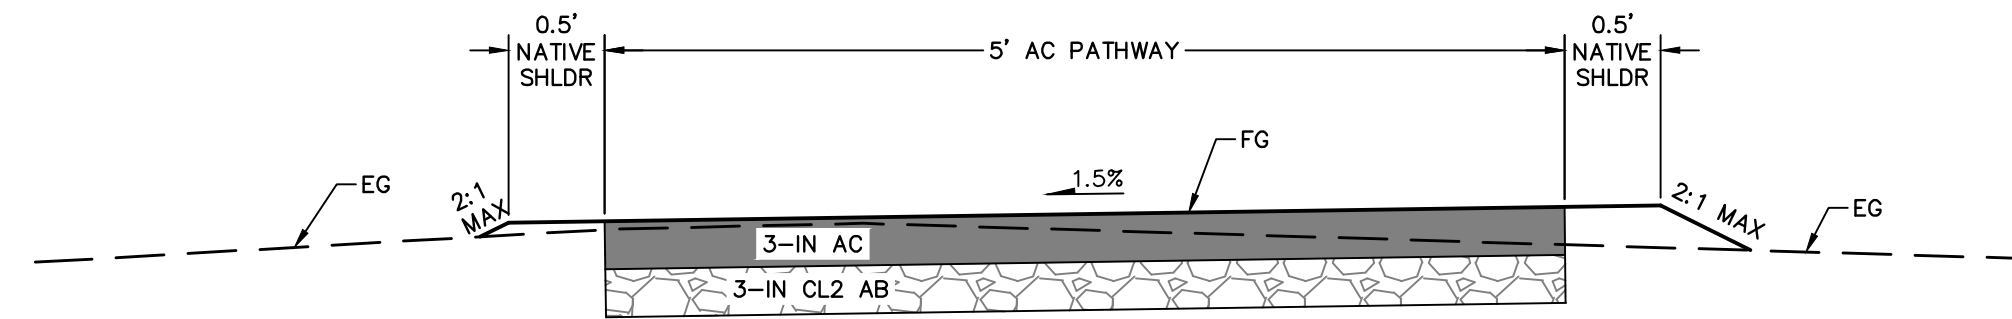


2  
-  
**TYPICAL PATHWAY SECTION 2**  
NTS PATHWAY STA 10+25 - 25+50

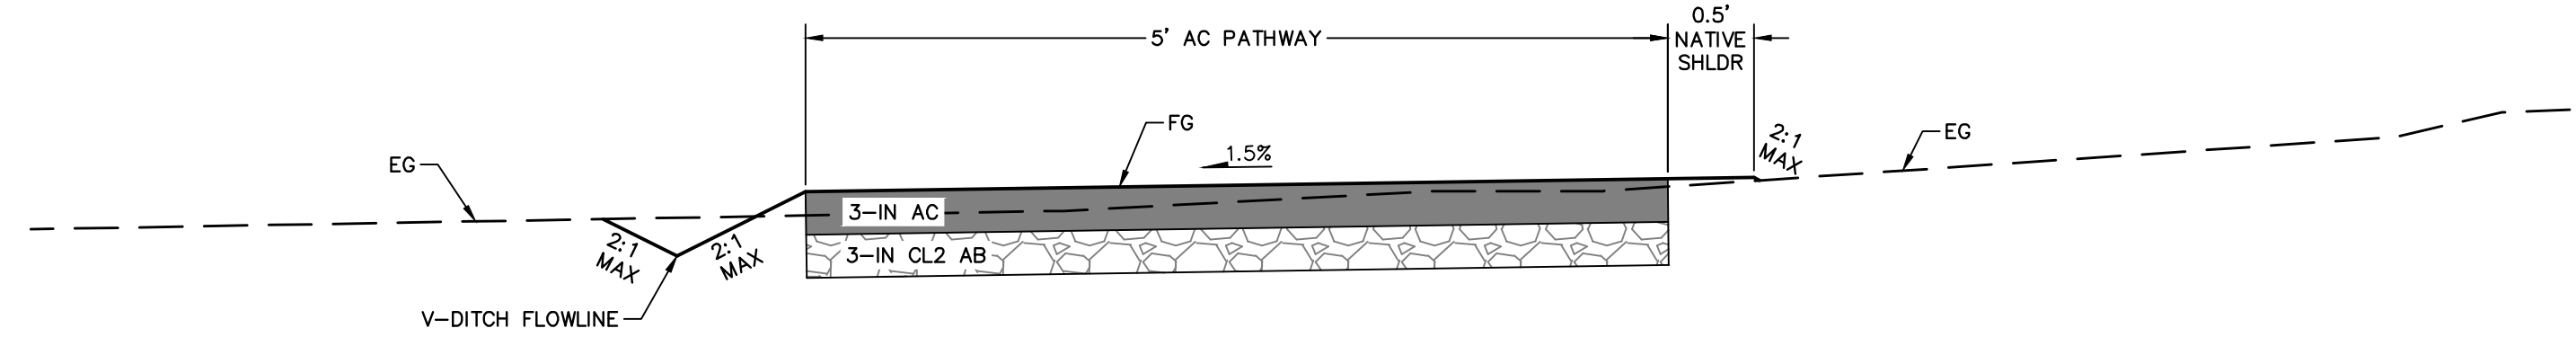

3  
-  
**TYPICAL PATHWAY SECTION 3**  
NTS PATHWAY STA 25+50 - 31+00

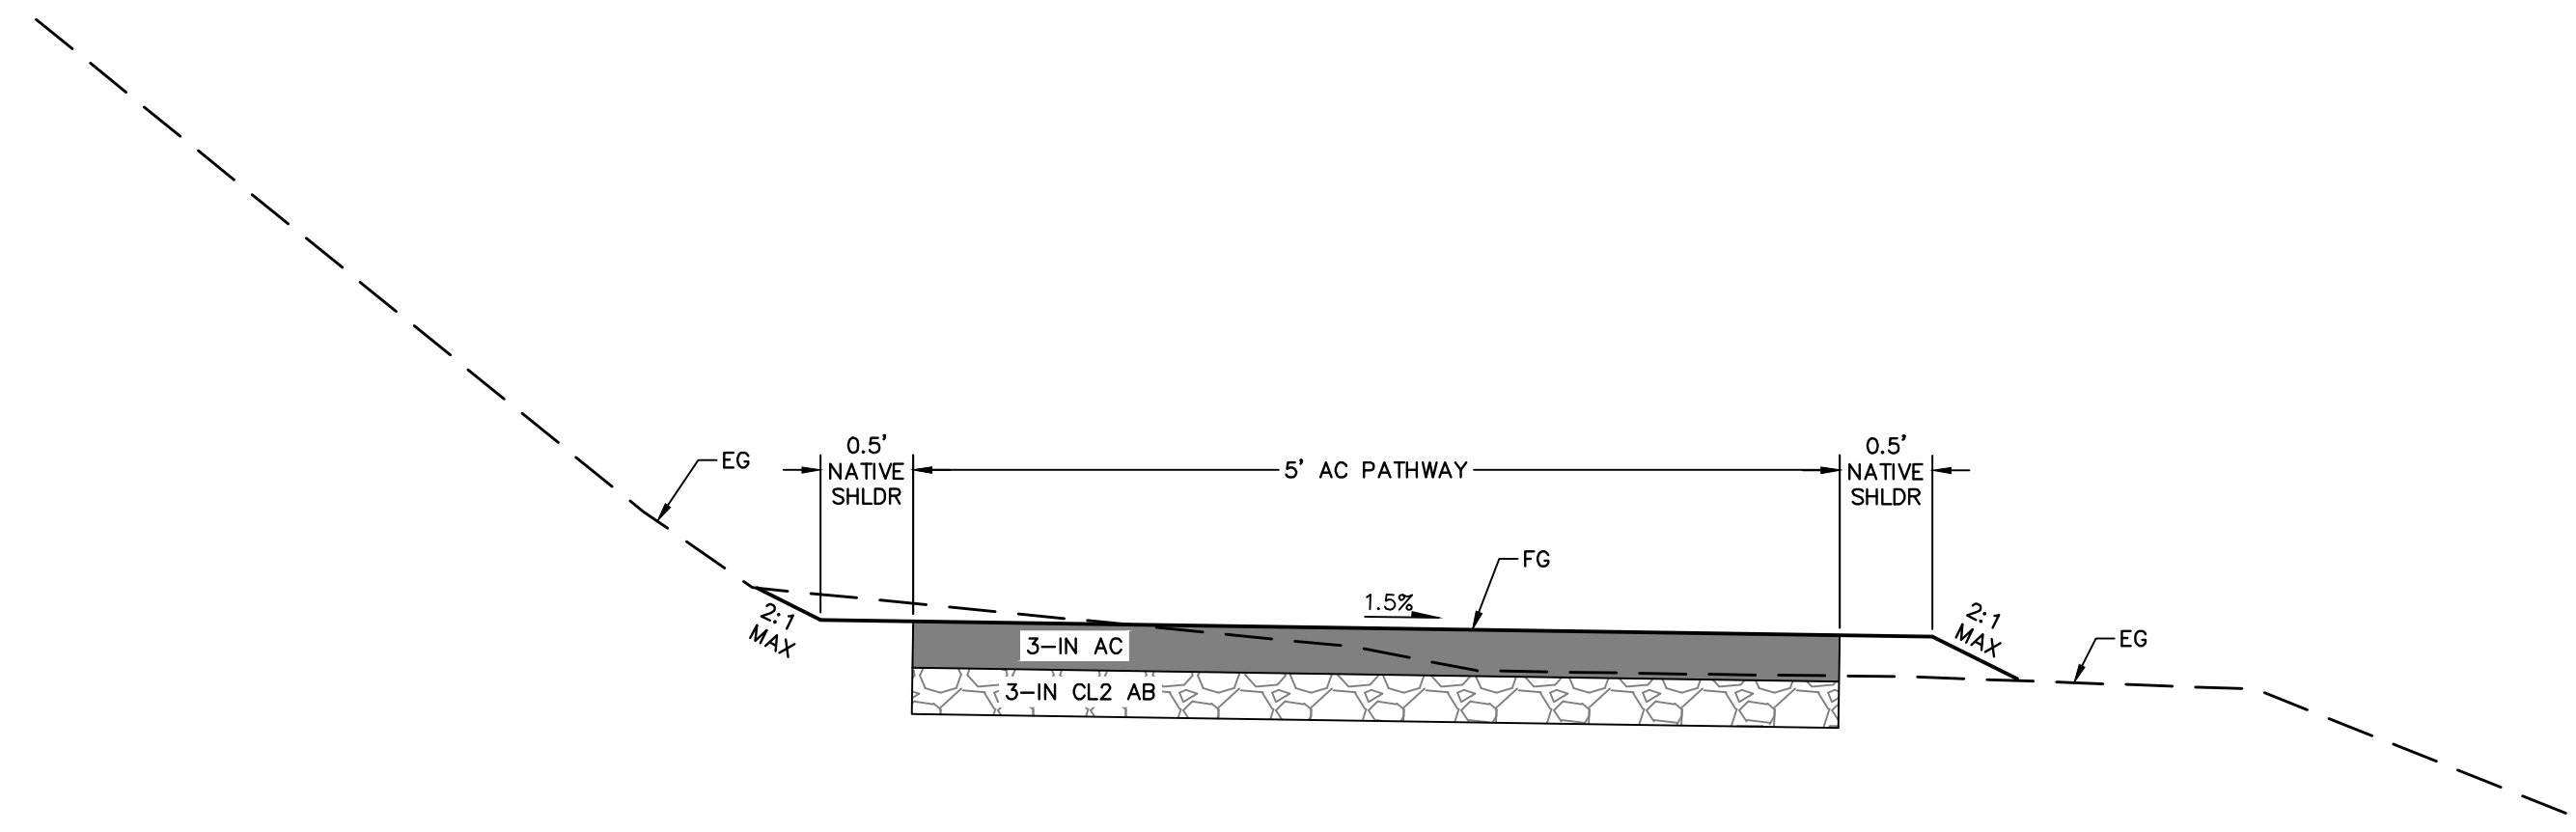

4  
-  
**TYPICAL PATHWAY SECTION 4**  
NTS PATHWAY STA 31+00 - END

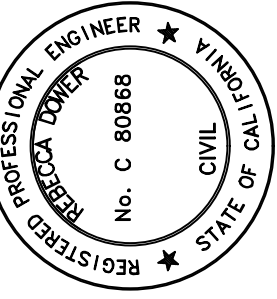

**PRELIMINARY**  
NOT FOR CONSTRUCTION  
DATE: 02/14/2024  
REBECCA DOWER  
C 80868

**BKF ENGINEERS**  
200 4th STREET  
SUITE 300  
SANTA ROSA, CA 95401  
(707) 583-8500  
www.bkf.com









**BOLINAS PATHWAY**  
APN 193-030-38  
MESA RD & OLEMA BOLINAS RD, BOLINAS, CA  
**TYPICAL SECTIONS**

Revisions	
No.	Description


Date: FEB 2024  
Scale: AS SHOWN  
Design: IC  
Drawn: AS  
Approved: BD  
Job No: 20220375

Drawing Number:  
**TS-1**  
2 OF 10

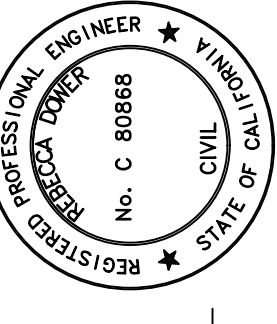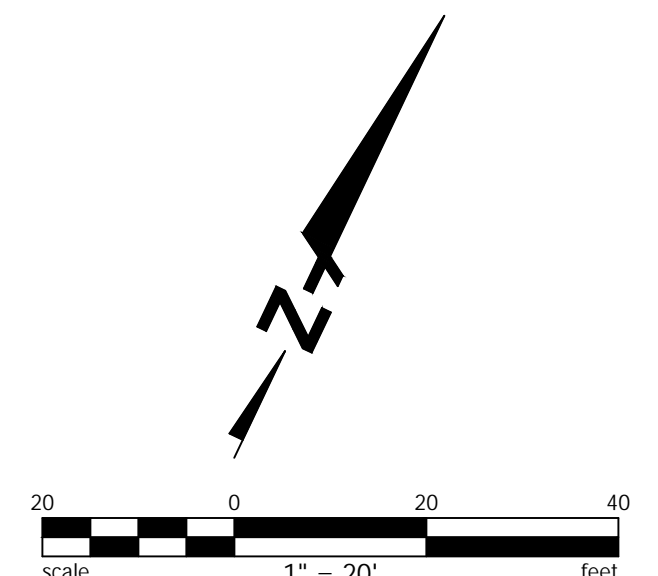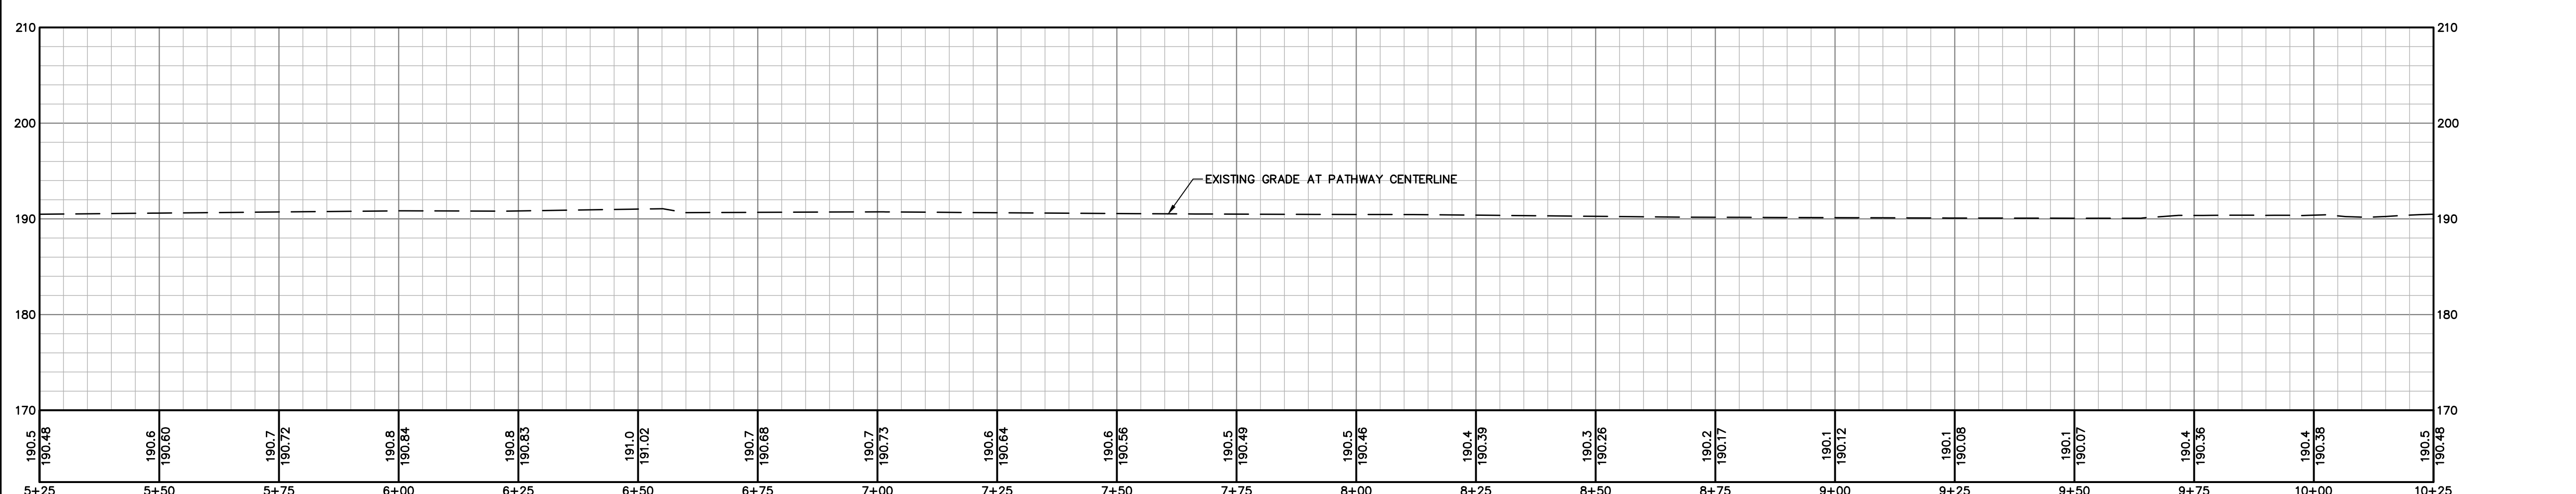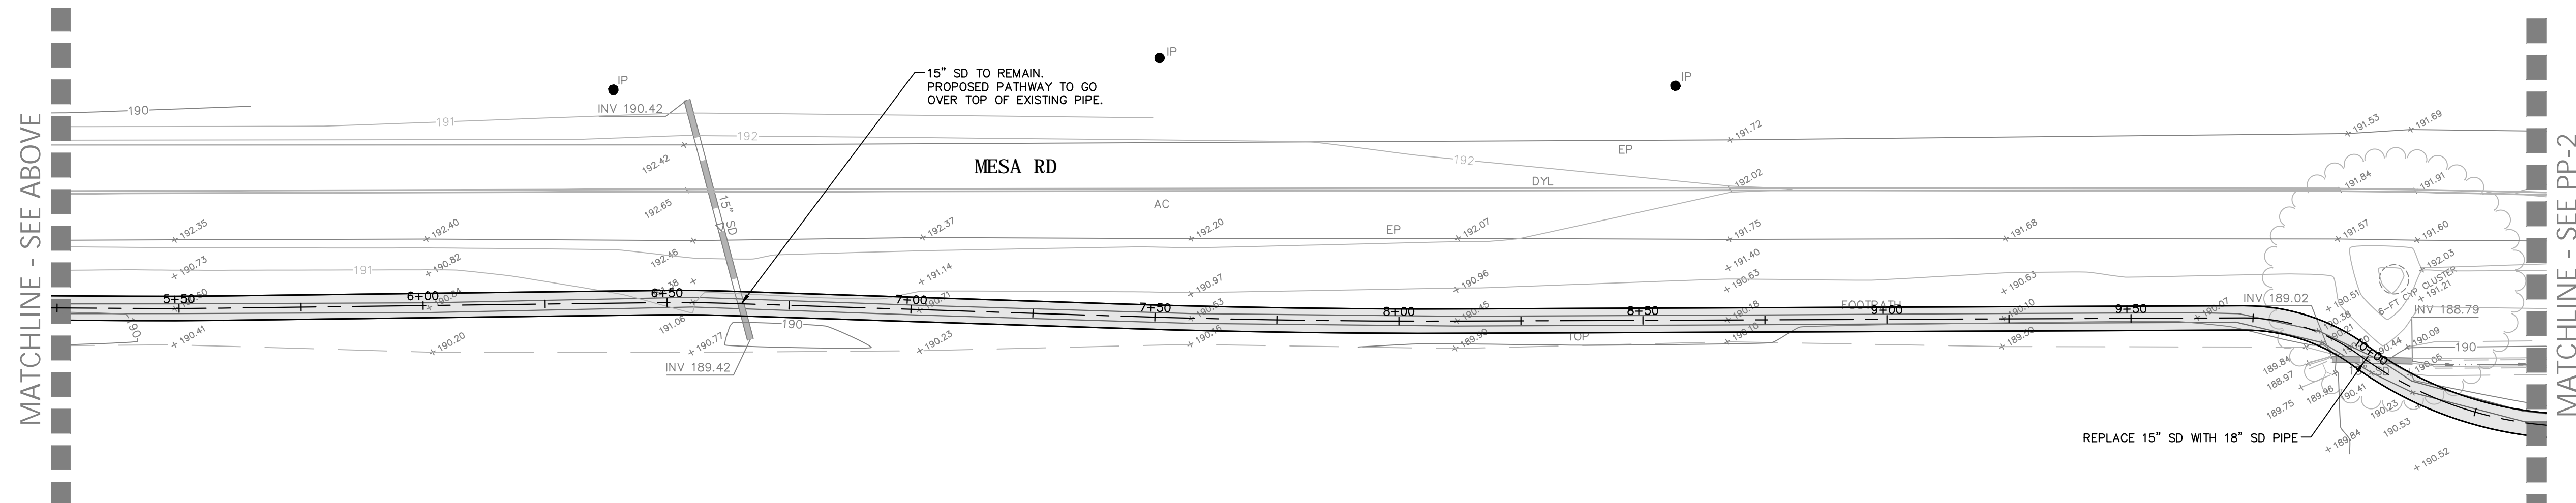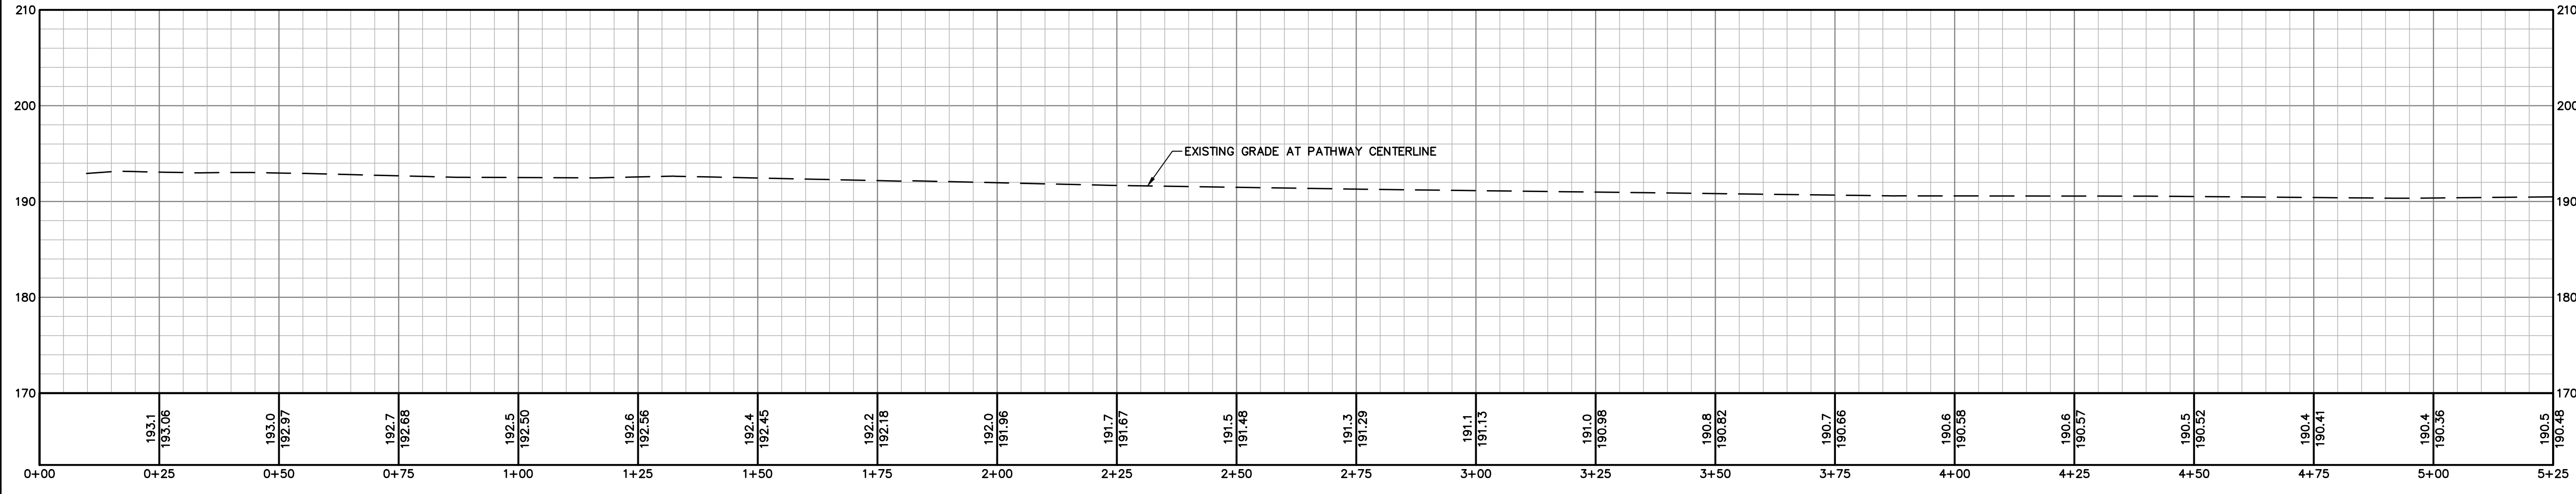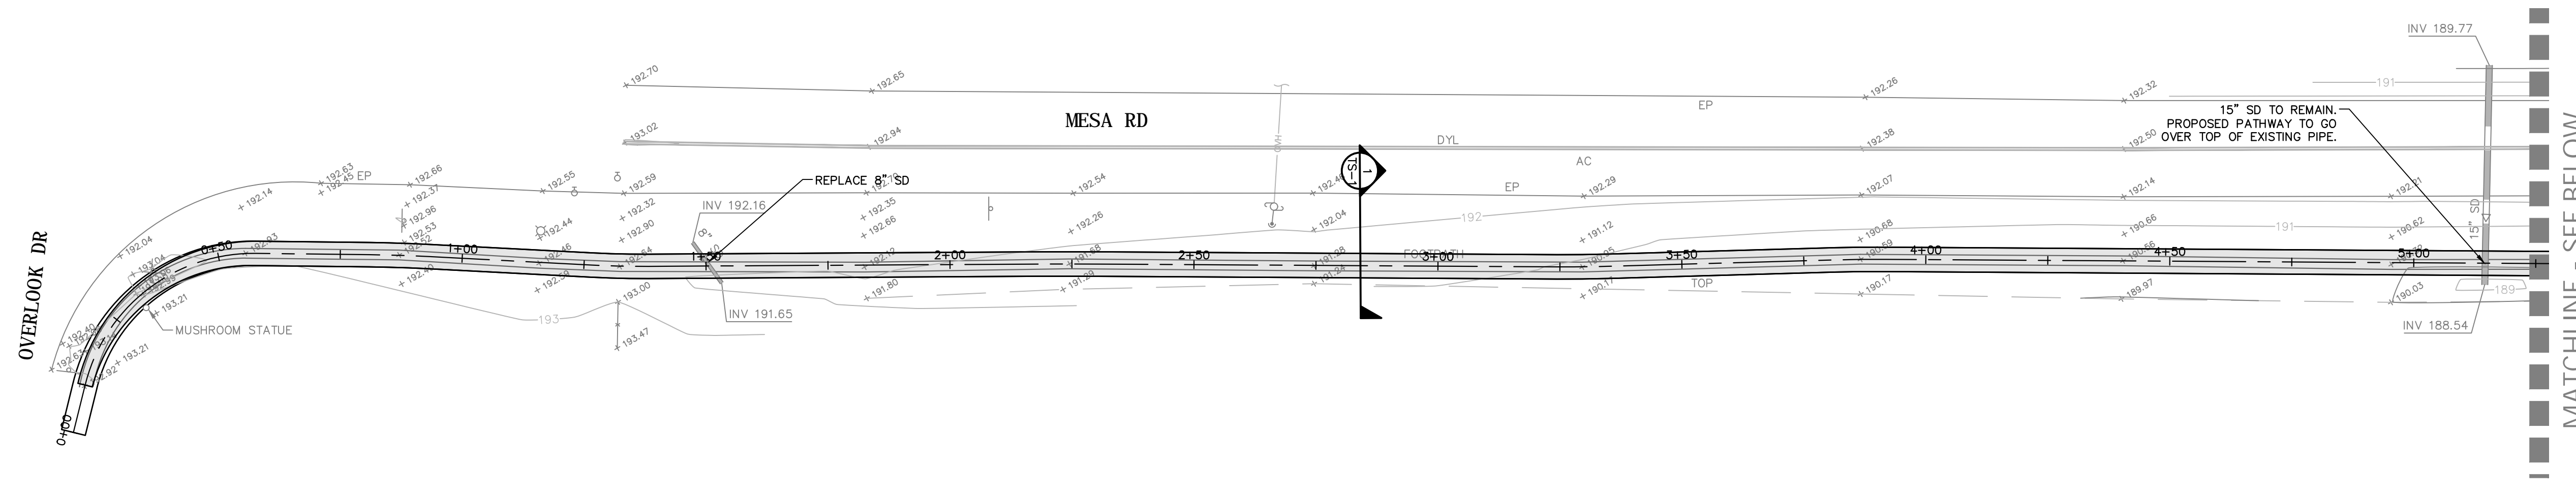

**PRELIMINARY**  
NOT FOR CONSTRUCTION  
DATE: 02/26/2024  
REBECCA DOWER  
C 80868





BKF ENGINEERS  
200 4TH STREET  
SANTA ROSA, CA 95401  
(707) 583-8500  
www.bkf.com

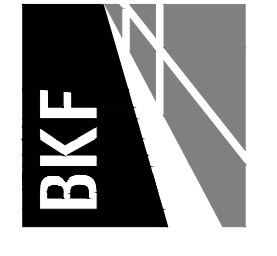

**BOLINAS PATHWAY**  
APN 193-030-38  
MESA RD & OLEMA BOLINAS RD, BOLINAS, CA  
**PATHWAY PLAN & PROFILE**  
STA 00+00 TO STA 10+25

Revisions	
No.	
Date: FEB 2024	
Scale: AS SHOWN	
Design: IC	
Drawn: AS	
Approved: BD	
Job No: 20220375	

Drawing Number:  
**PP-1**  
3 OF 10

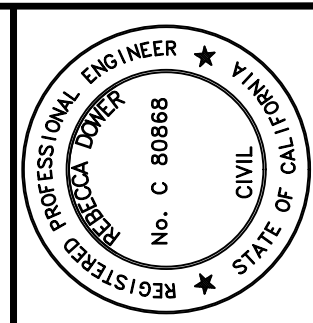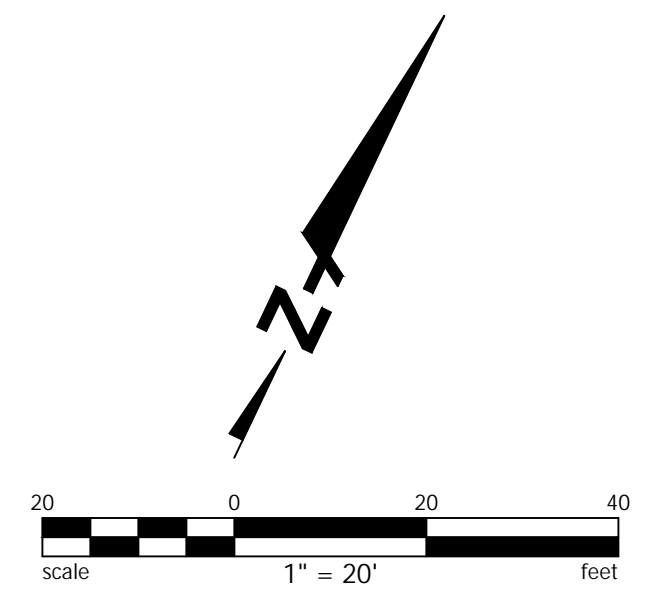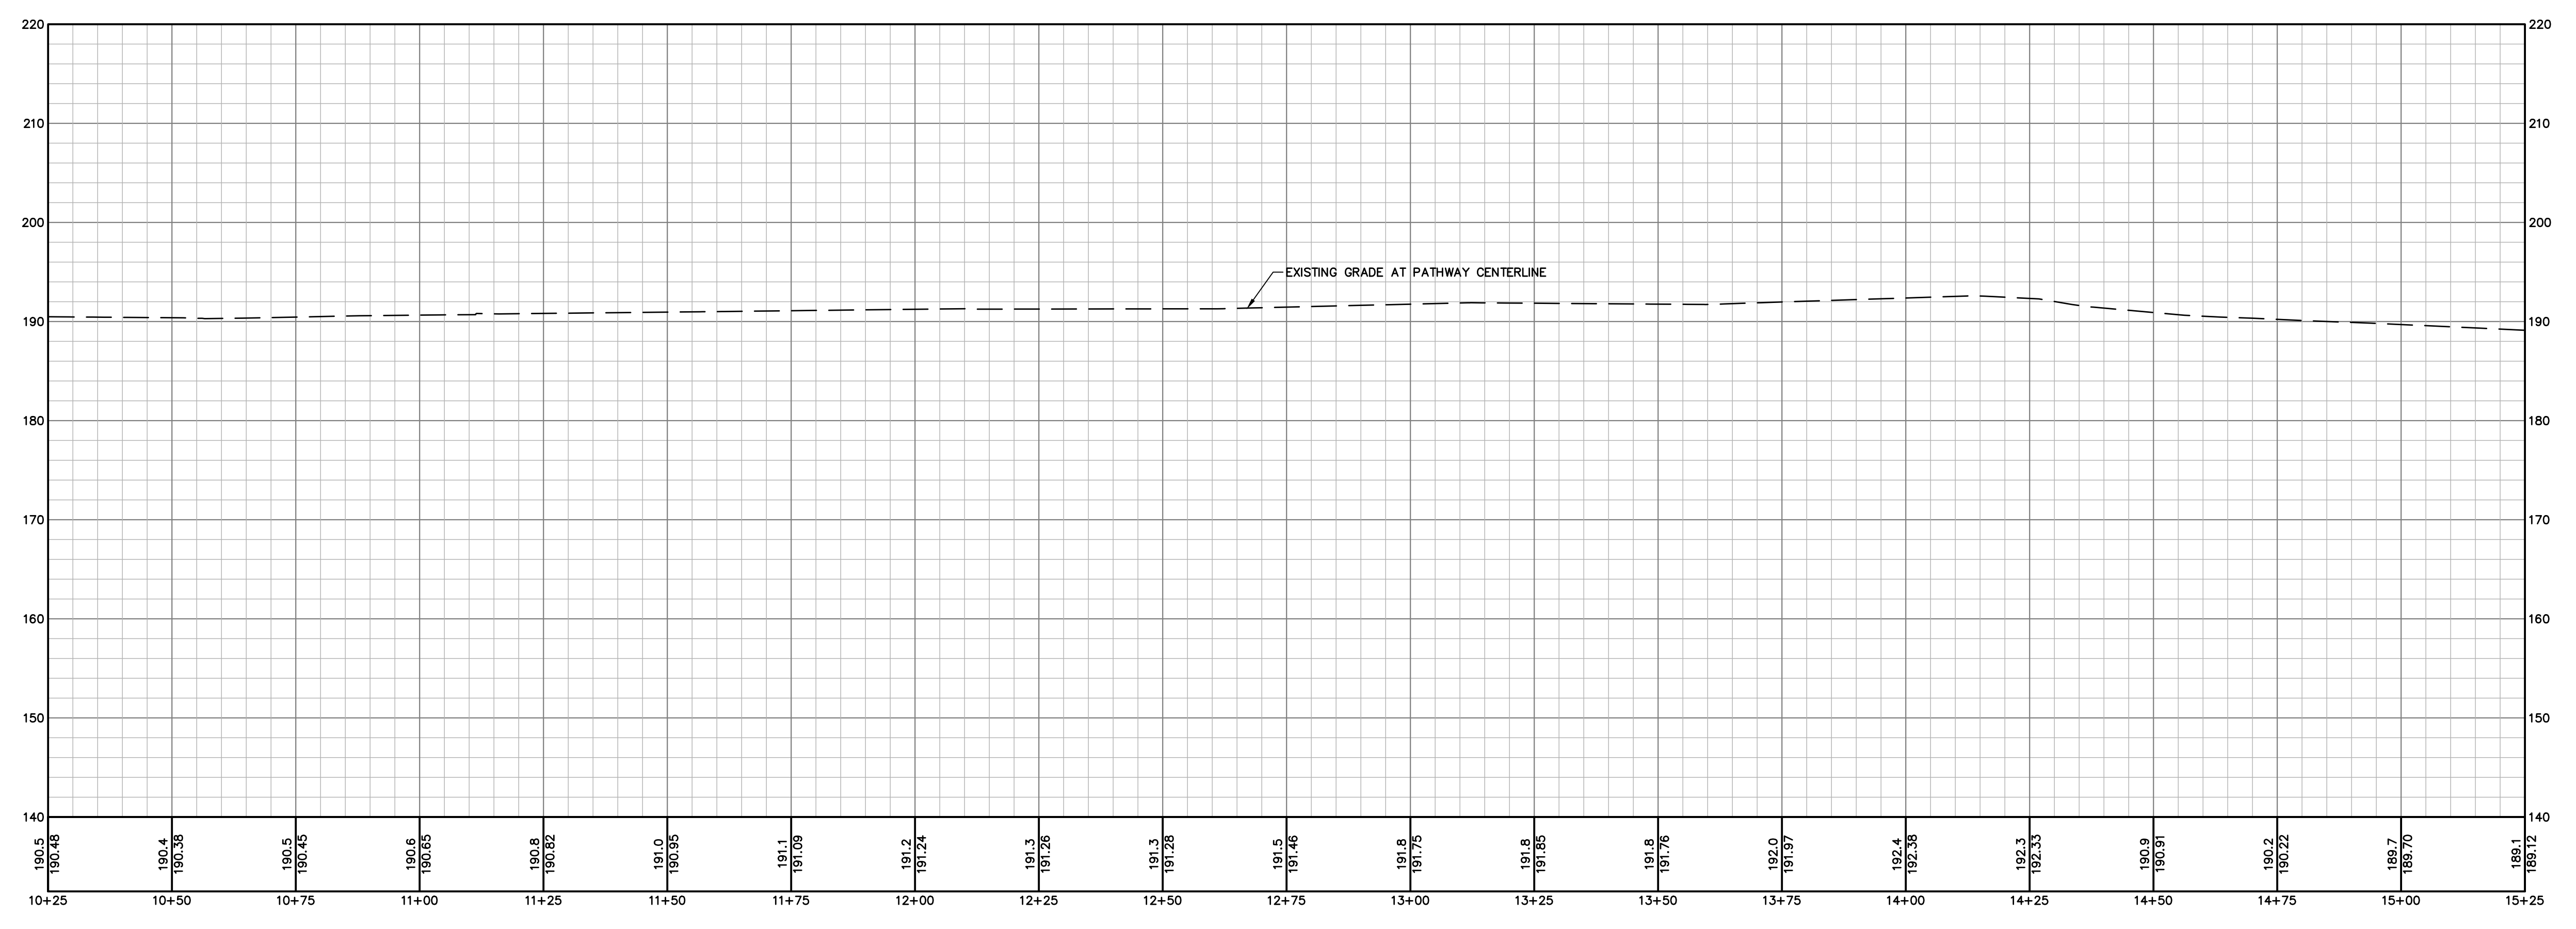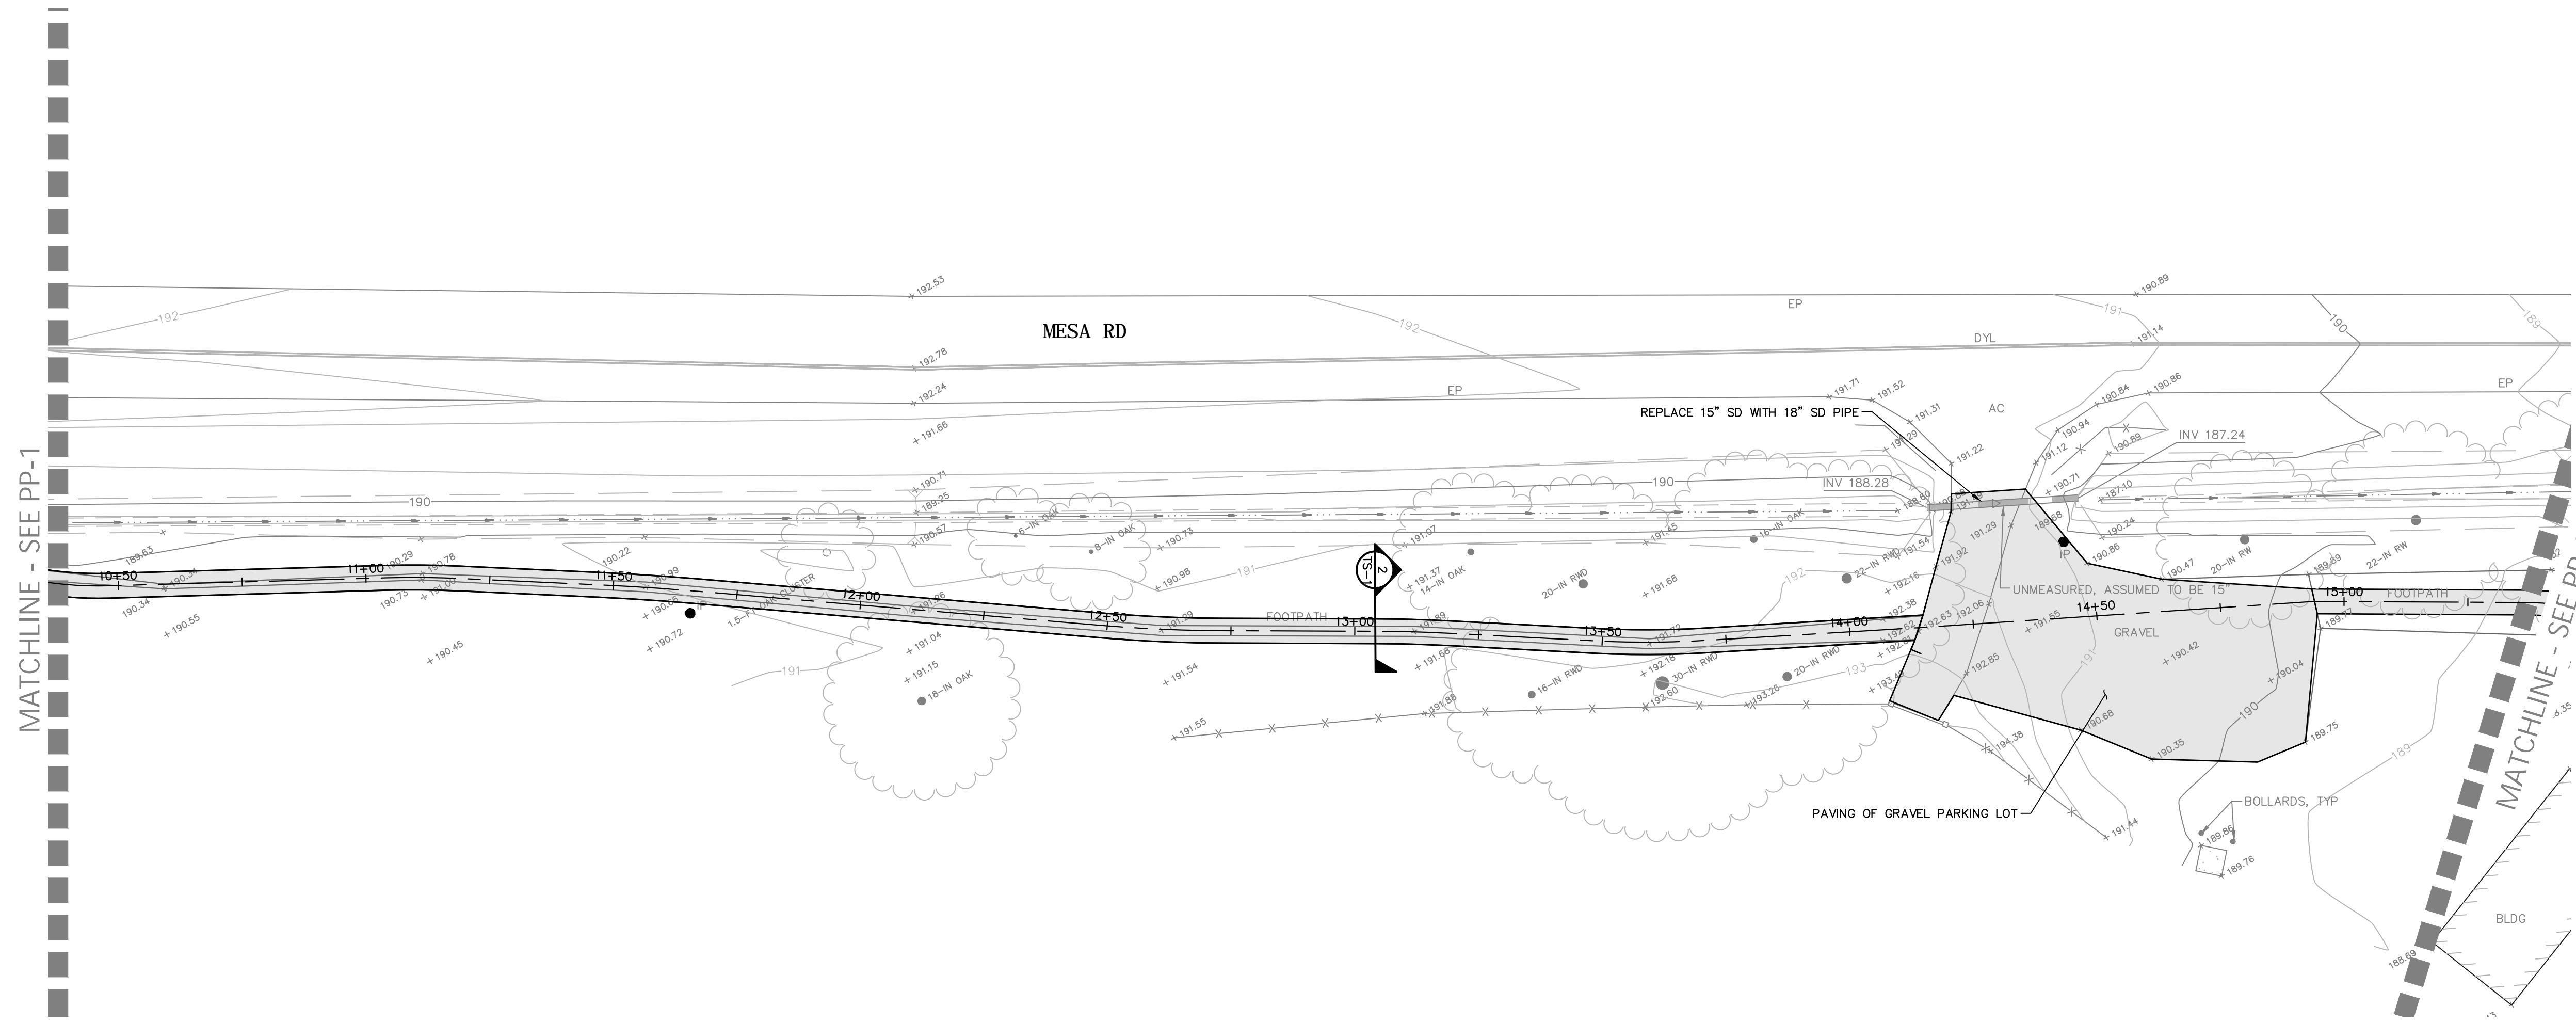

**PRELIMINARY**  
NOT FOR CONSTRUCTION  
DATE: 02/26/2024  
REBECCA DOWER  
C 80868





BKF ENGINEERS  
200 4TH STREET  
SANTA ROSA, CA 95401  
(707) 583-8500  
www.bkf.com



BOLINAS PATHWAY  
APN 193-030-38  
MESA RD & OLEMA BOLINAS RD, BOLINAS, CA  
**PATHWAY PLAN & PROFILE**  
STA 10+25 TO STA 15+25

Revisions	
No.	Description

Date: FEB 2024  
Scale: AS SHOWN  
Design: IC  
Drawn: AS  
Approved: BD  
Job No: 20220375  
Drawing Number:  
**PP-2**  
4 OF 10

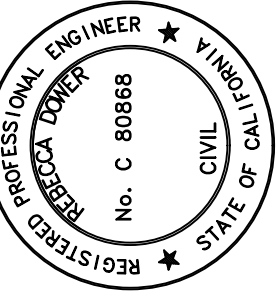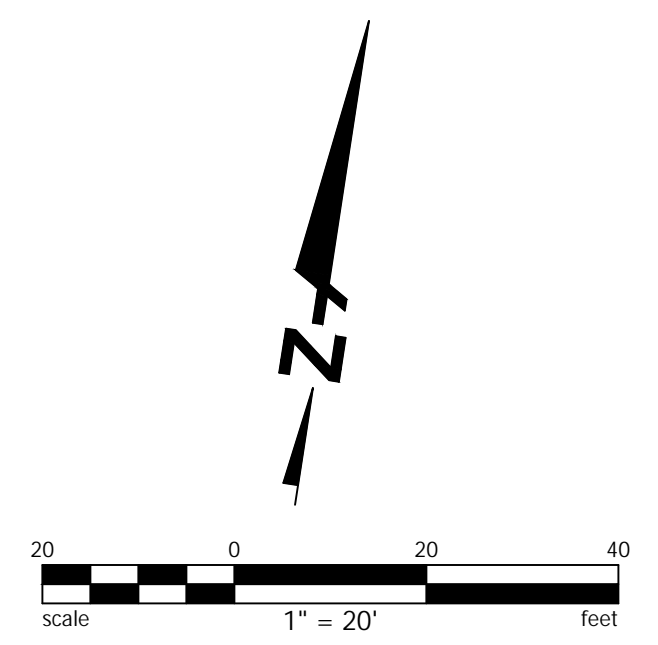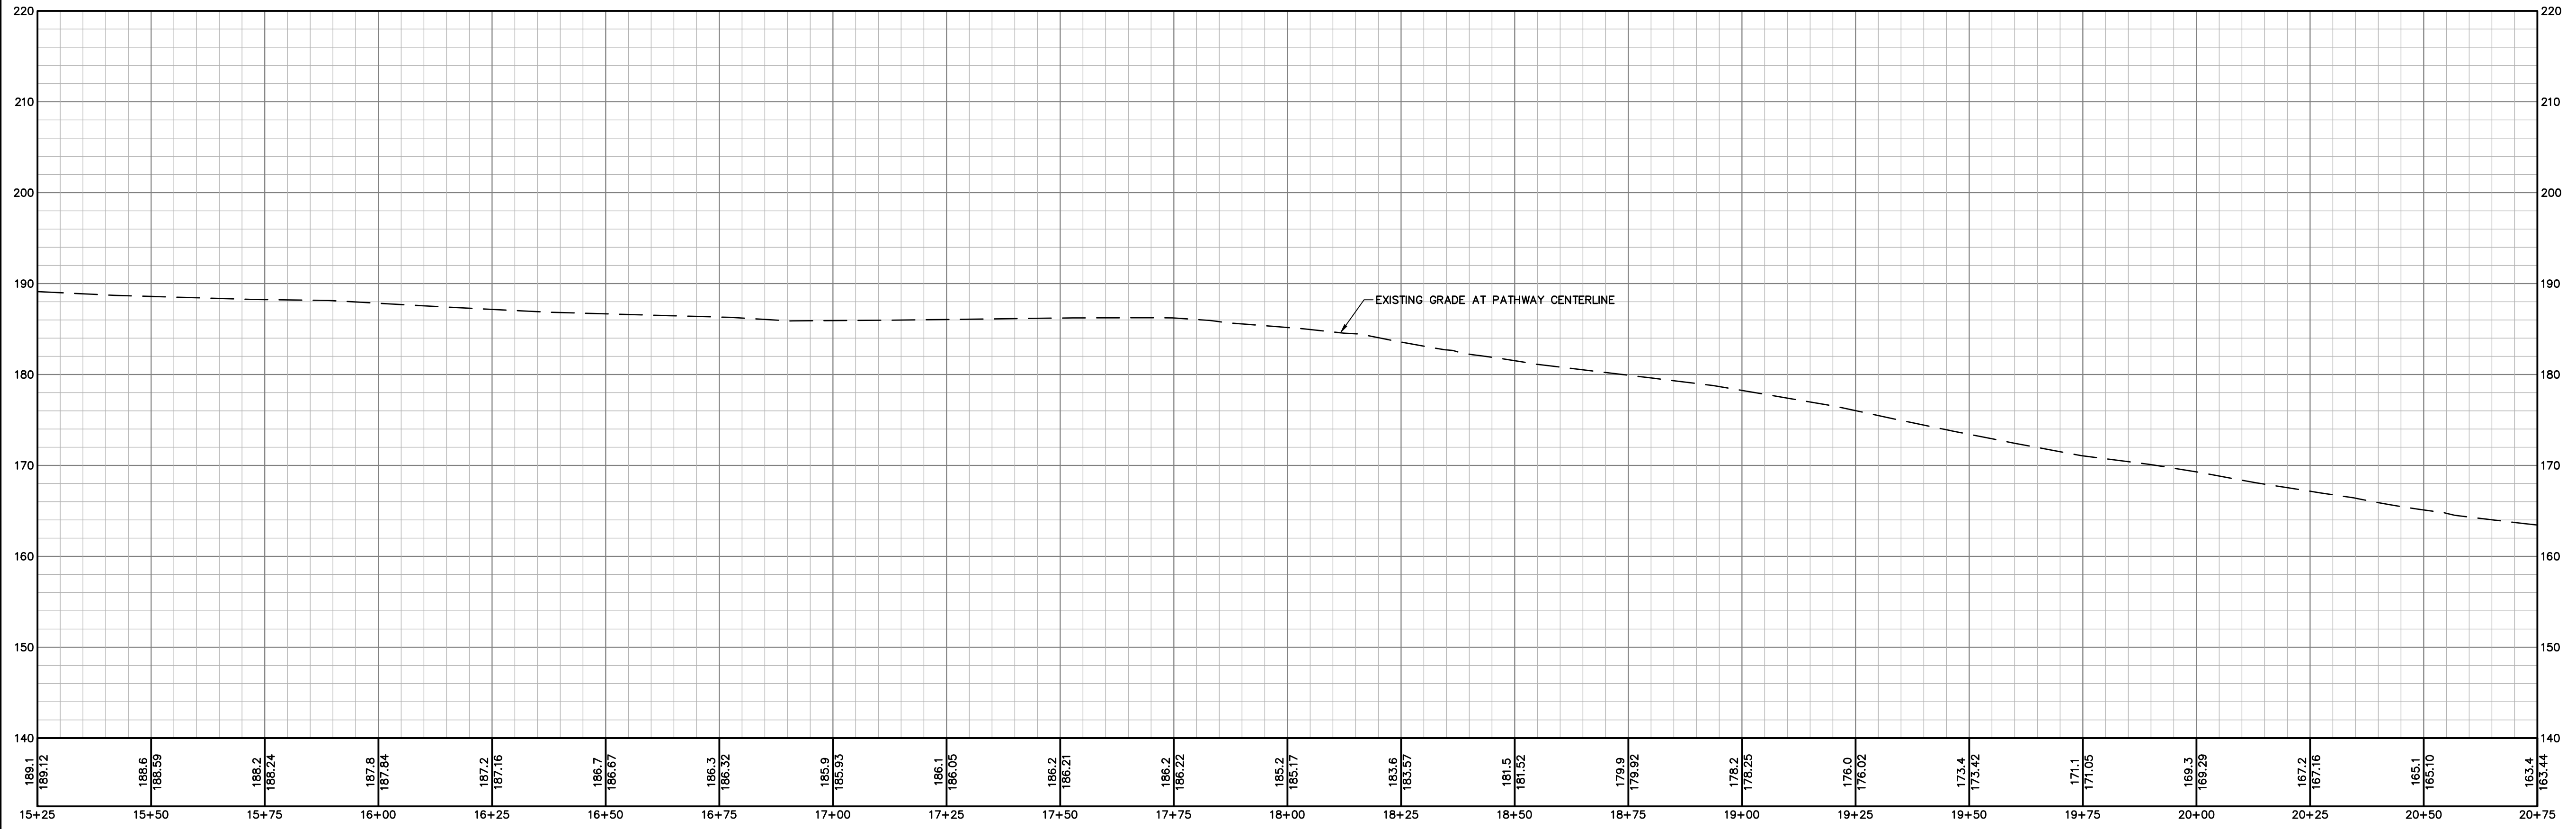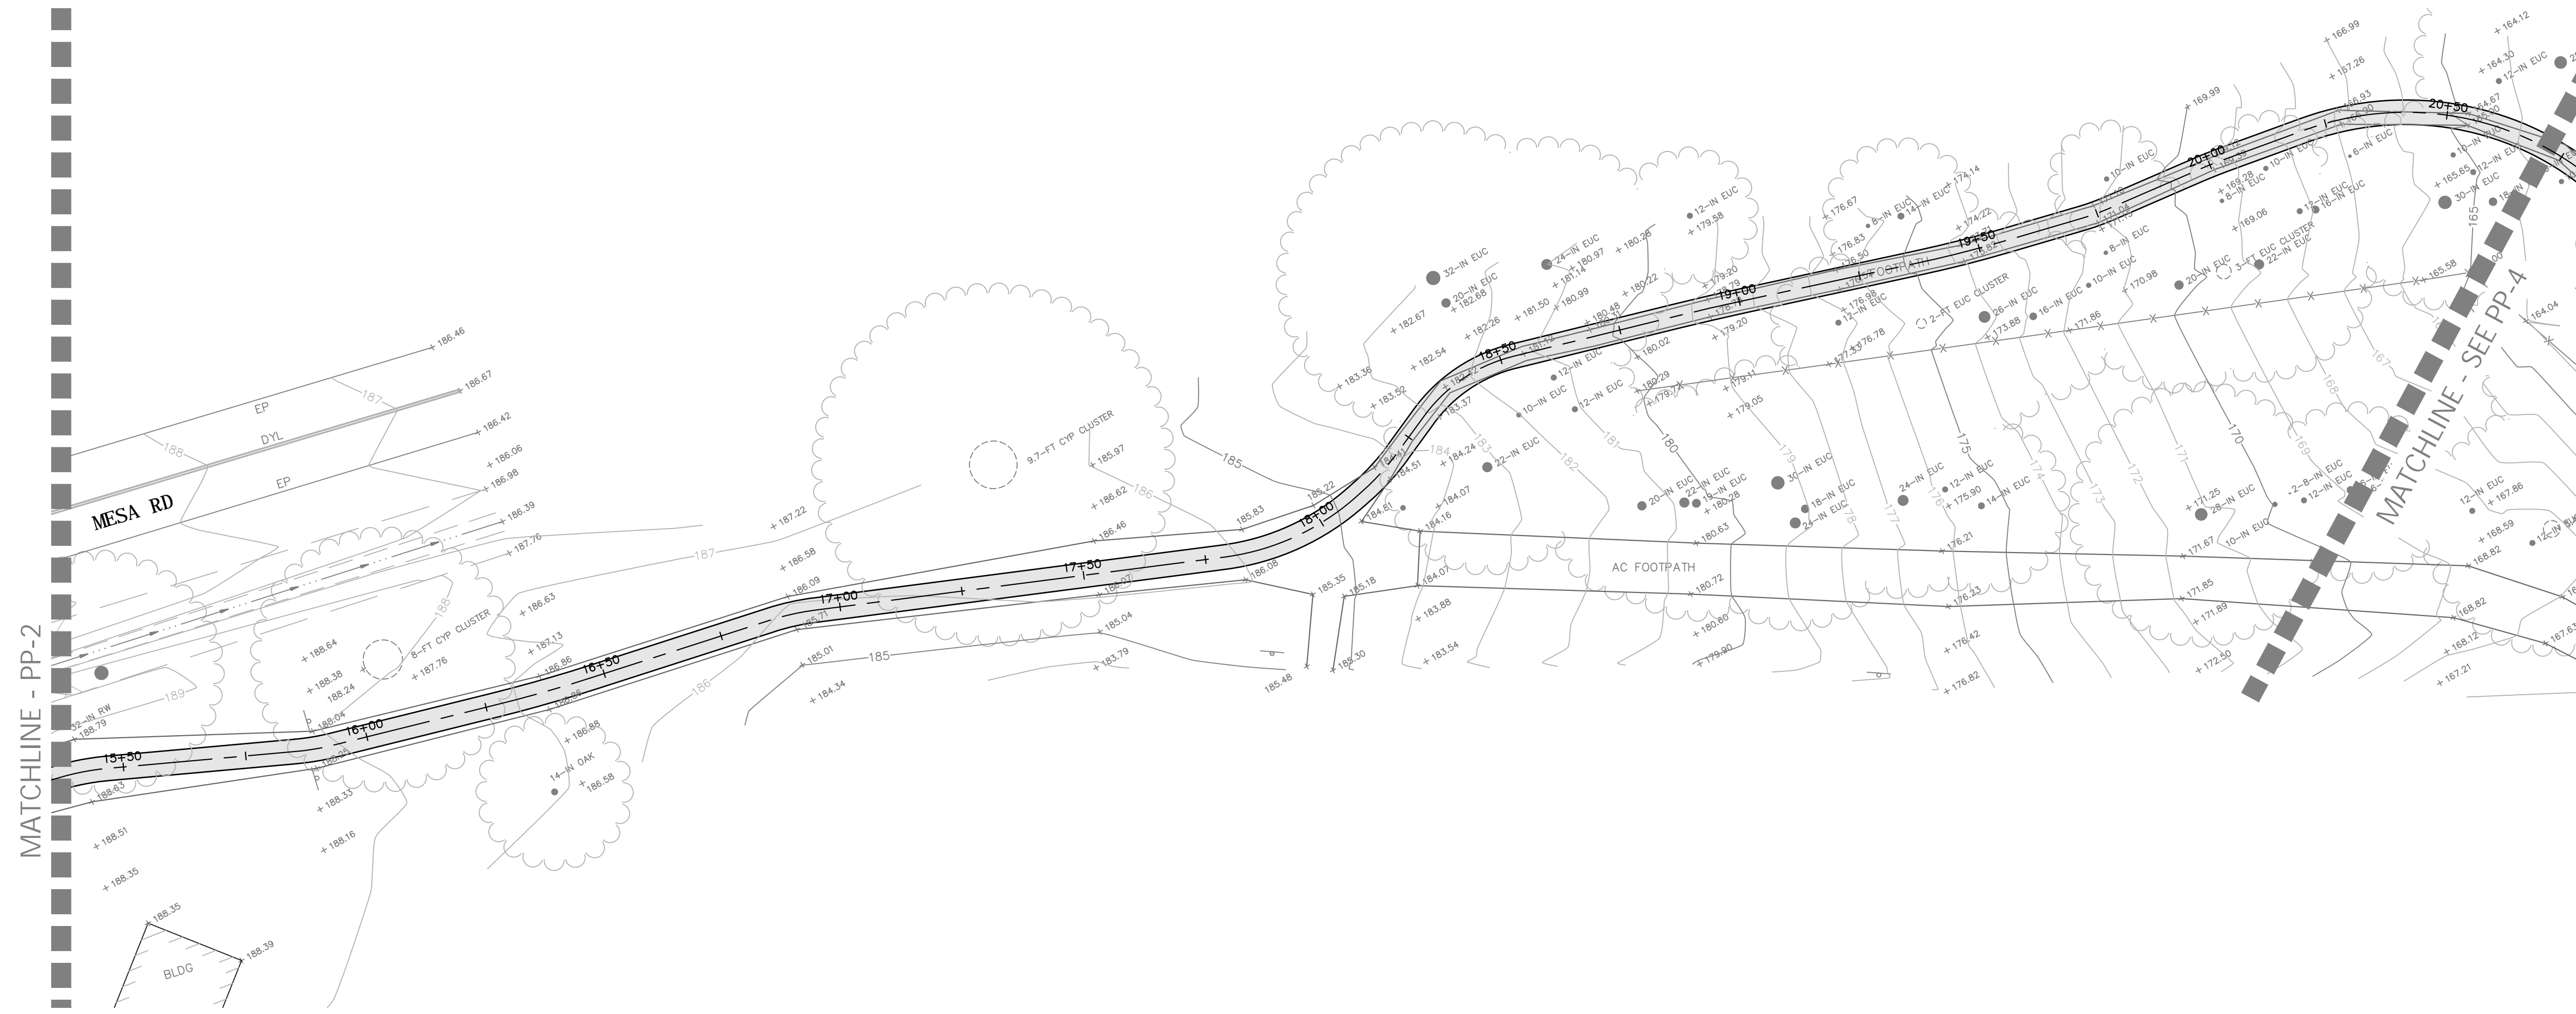

**PRELIMINARY**  
NOT FOR CONSTRUCTION  
DATE: 02/26/2024  
REBECCA DOWER  
C 80868





BKF ENGINEERS  
200 4th STREET  
SANTA ROSA, CA 95401  
(707) 583-8500  
www.bkf.com



**BOLINAS PATHWAY**  
APN 193-030-38  
MESA RD & OLEMA BOLINAS RD, BOLINAS, CA  
**PATHWAY PLAN & PROFILE**  
STA 15+25 TO STA 20+75

Revisions	
No.	Date
	FEB 2024
	AS SHOWN
	Design: IC
	Drawn: AS
	Approved: BD
	Job No: 20220375

Drawing Number:  
**PP-3**  
5 OF 10

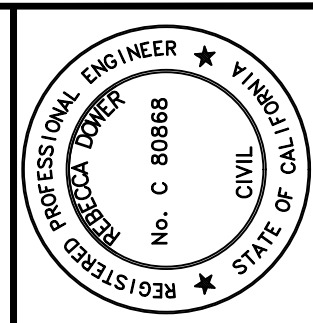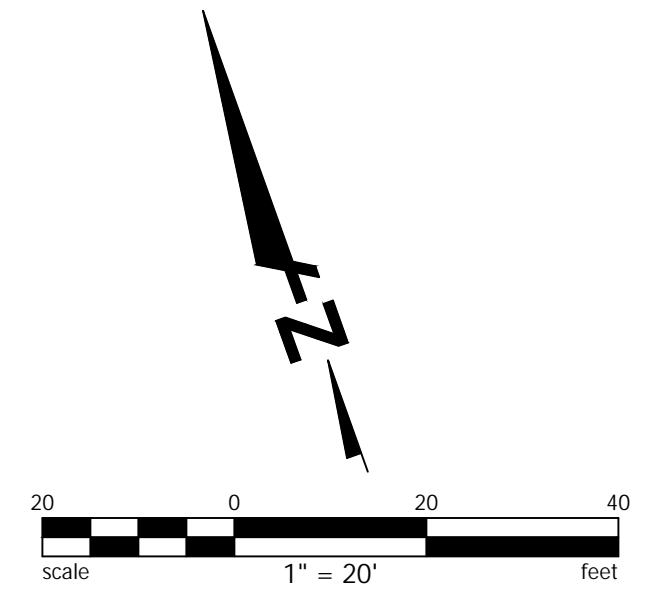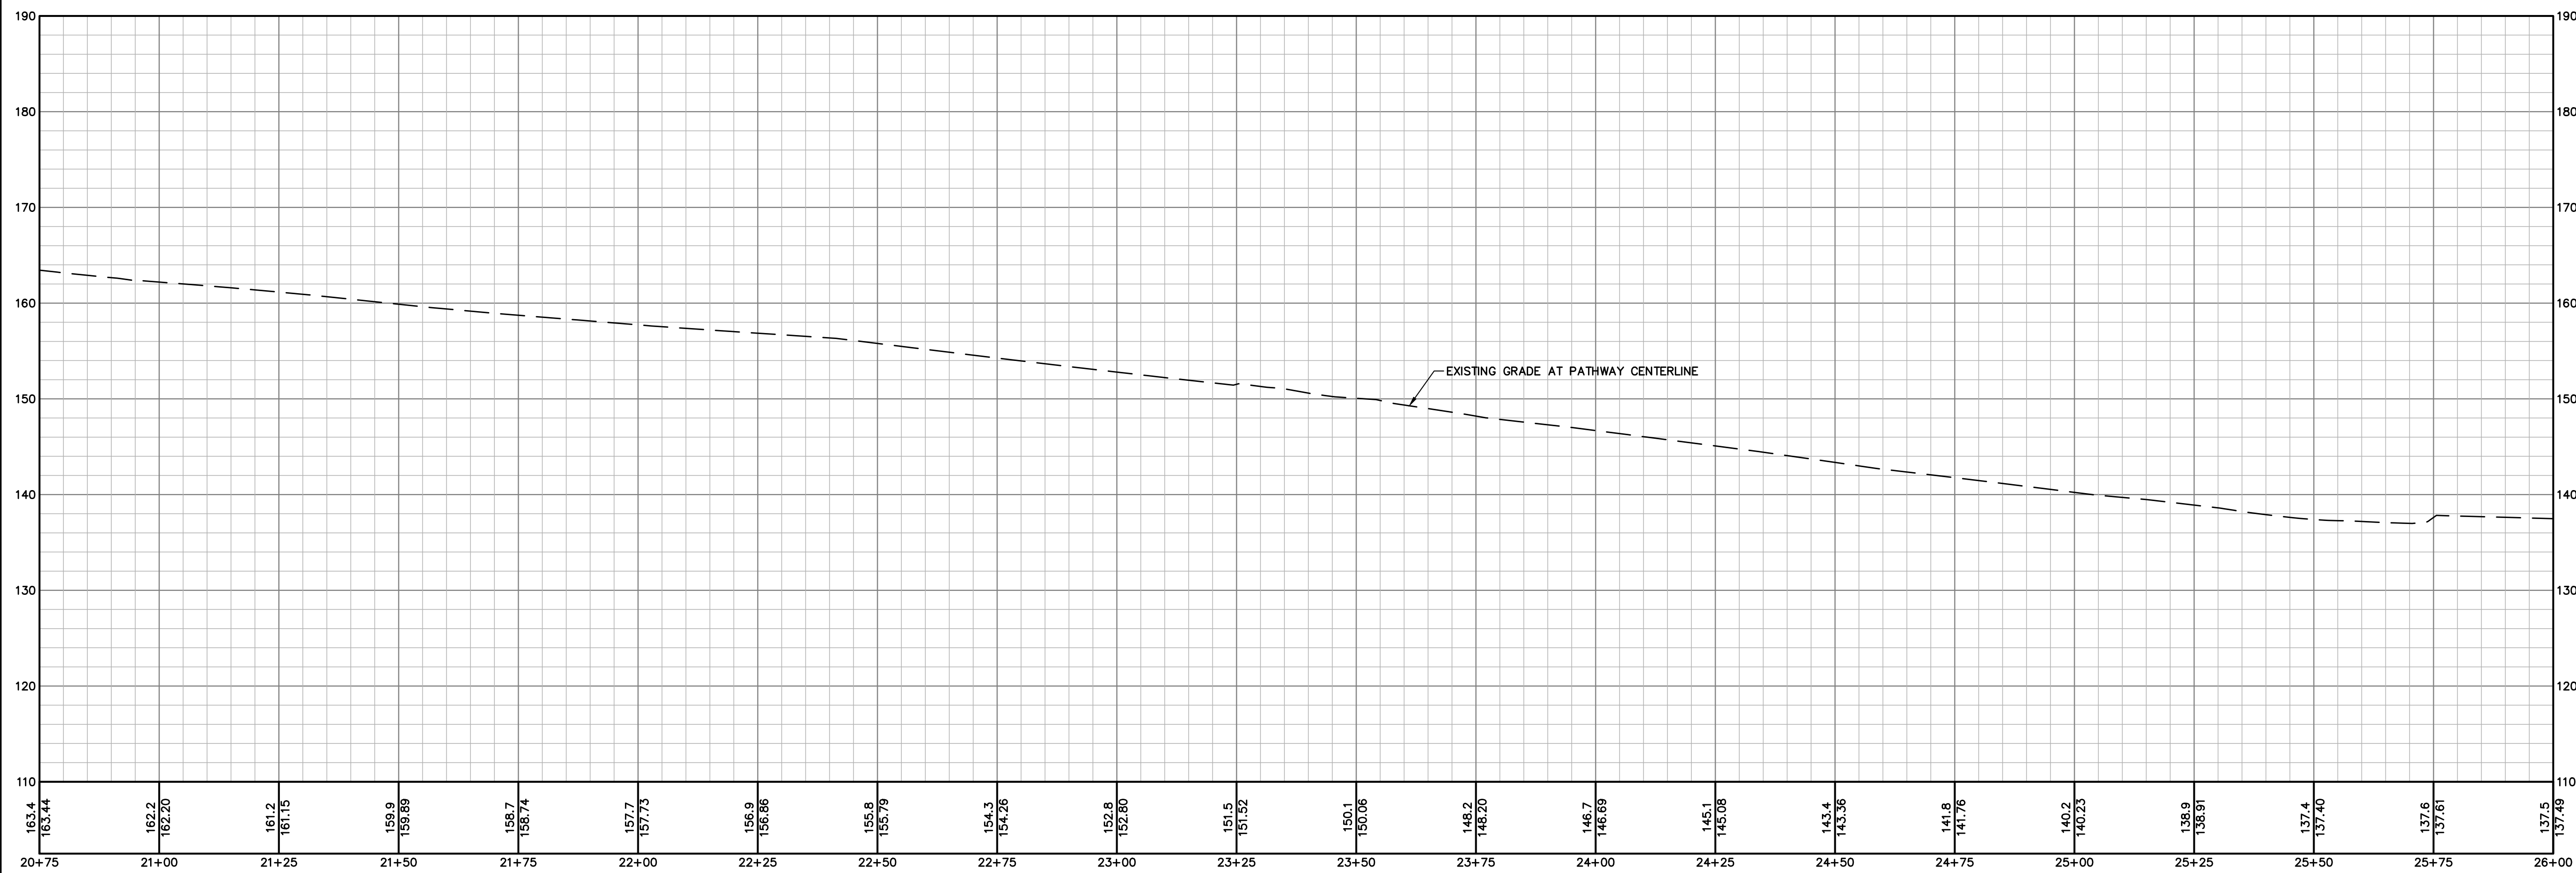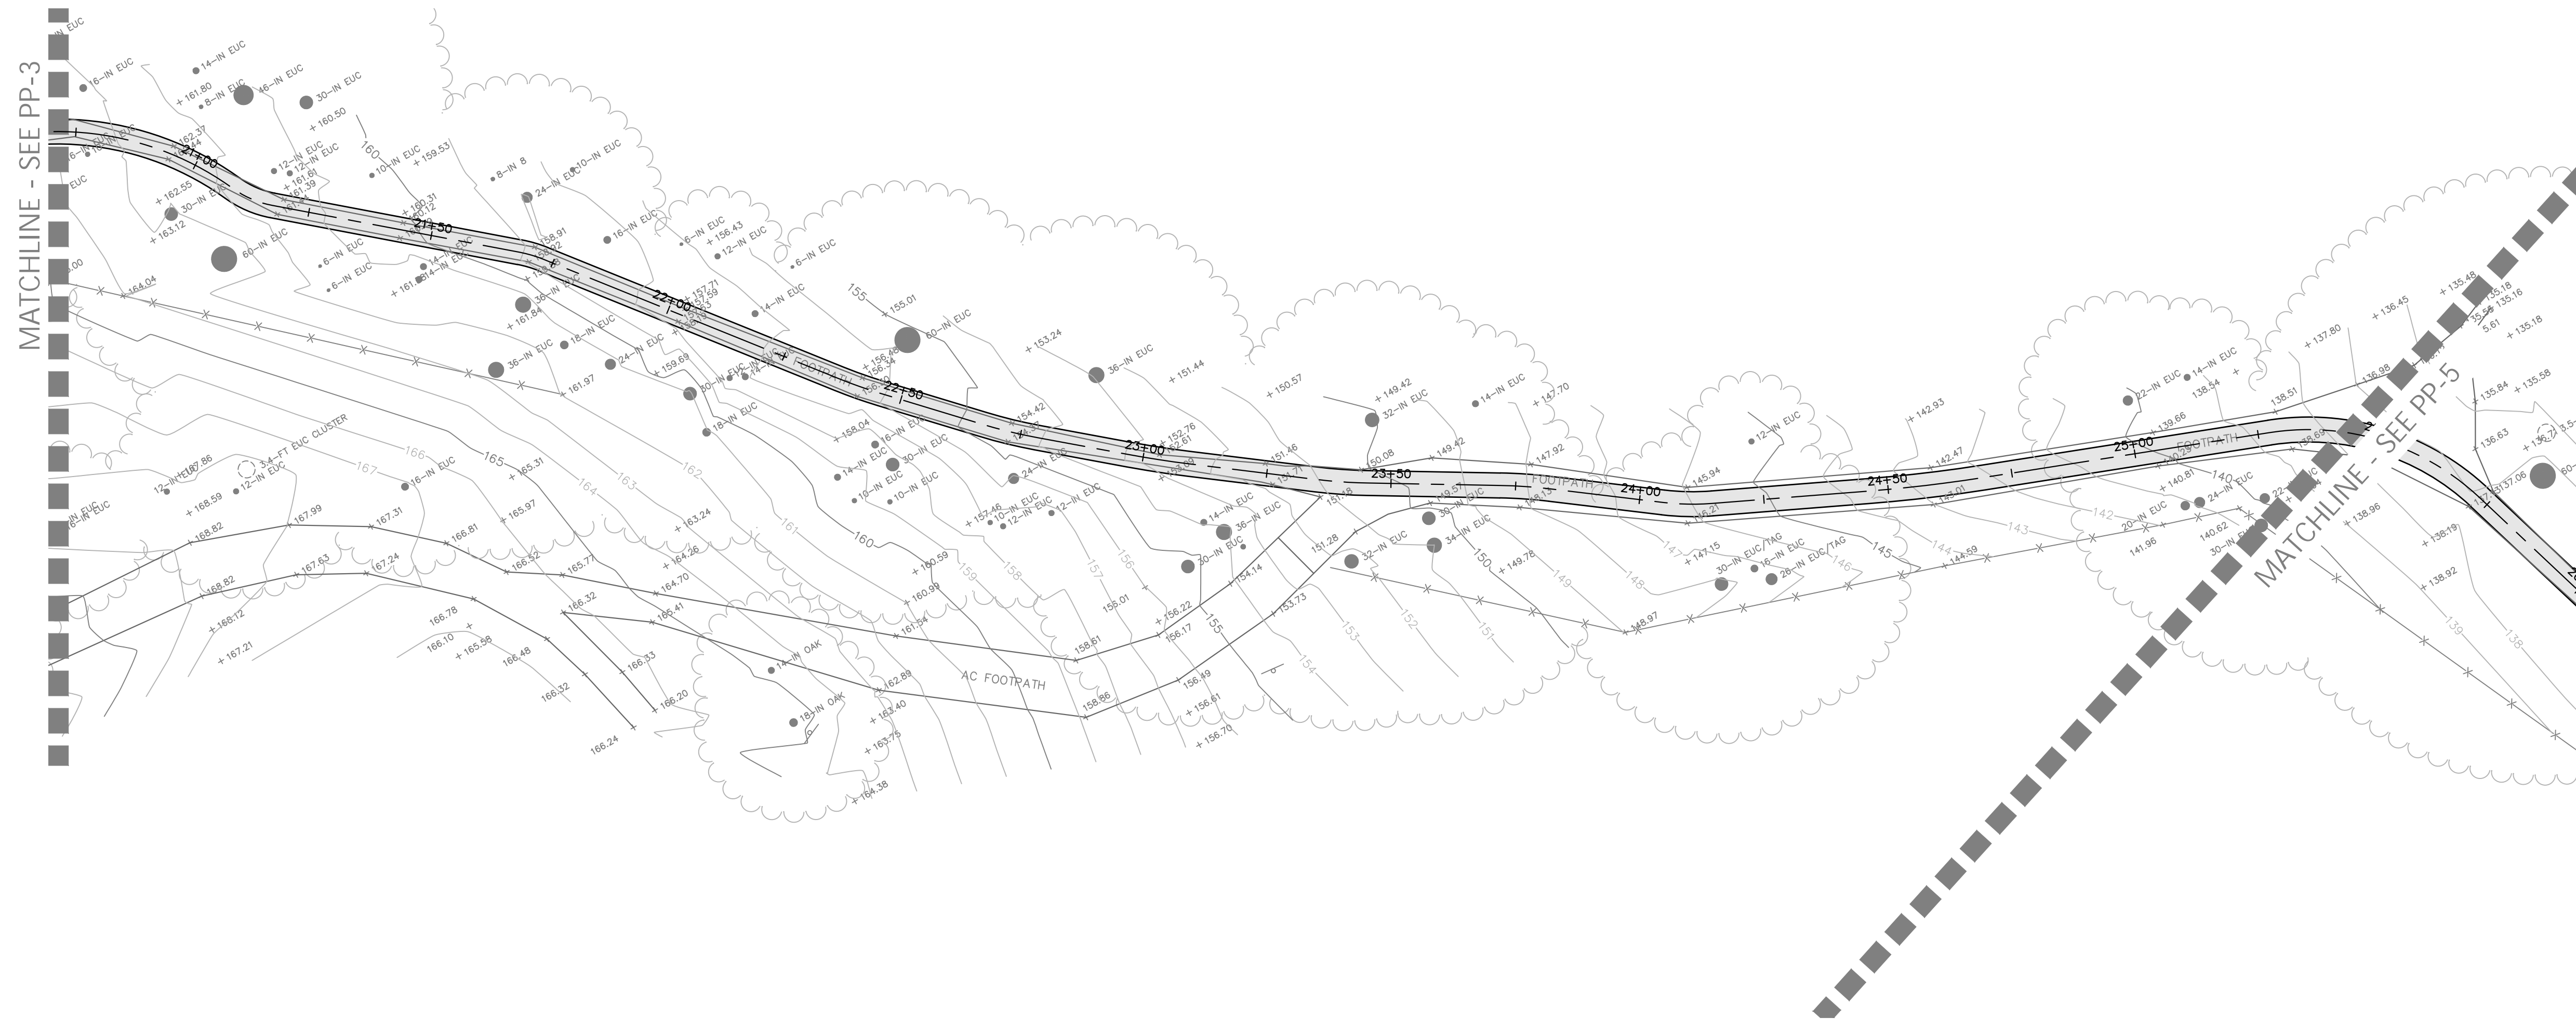

**PRELIMINARY**  
NOT FOR CONSTRUCTION  
DATE: 02/26/2024  
REBECCA DOWER  
C 80868





BKF ENGINEERS  
200 4th STREET  
SANTA ROSA, CA 95401  
(707) 583-8500  
www.bkf.com



**BOLINAS PATHWAY**  
APN 193-030-38  
MESA RD & OLEMA BOLINAS RD, BOLINAS, CA  
**PATHWAY PLAN & PROFILE**  
STA 20+75 TO STA 26+00

Revisions	
No.	Description

Date: FEB 2024  
Scale: AS SHOWN  
Design: C  
Drawn: AS  
Approved: BD  
Job No: 20220375  
Drawing Number:  
**PP-4**  
6 OF 10

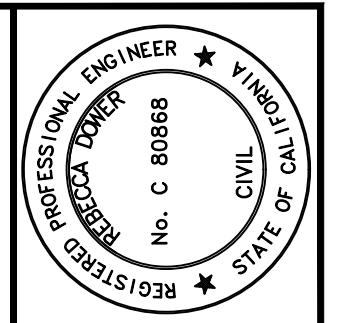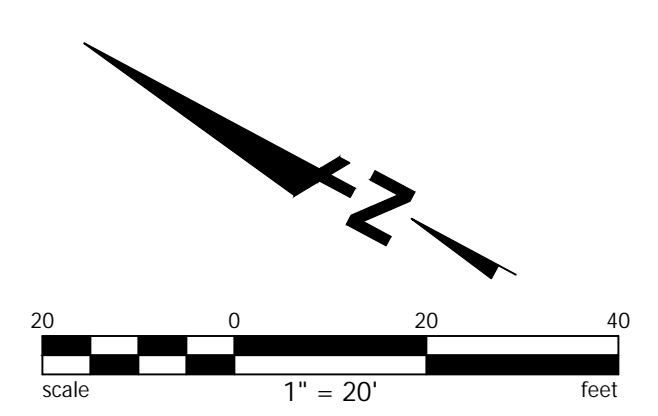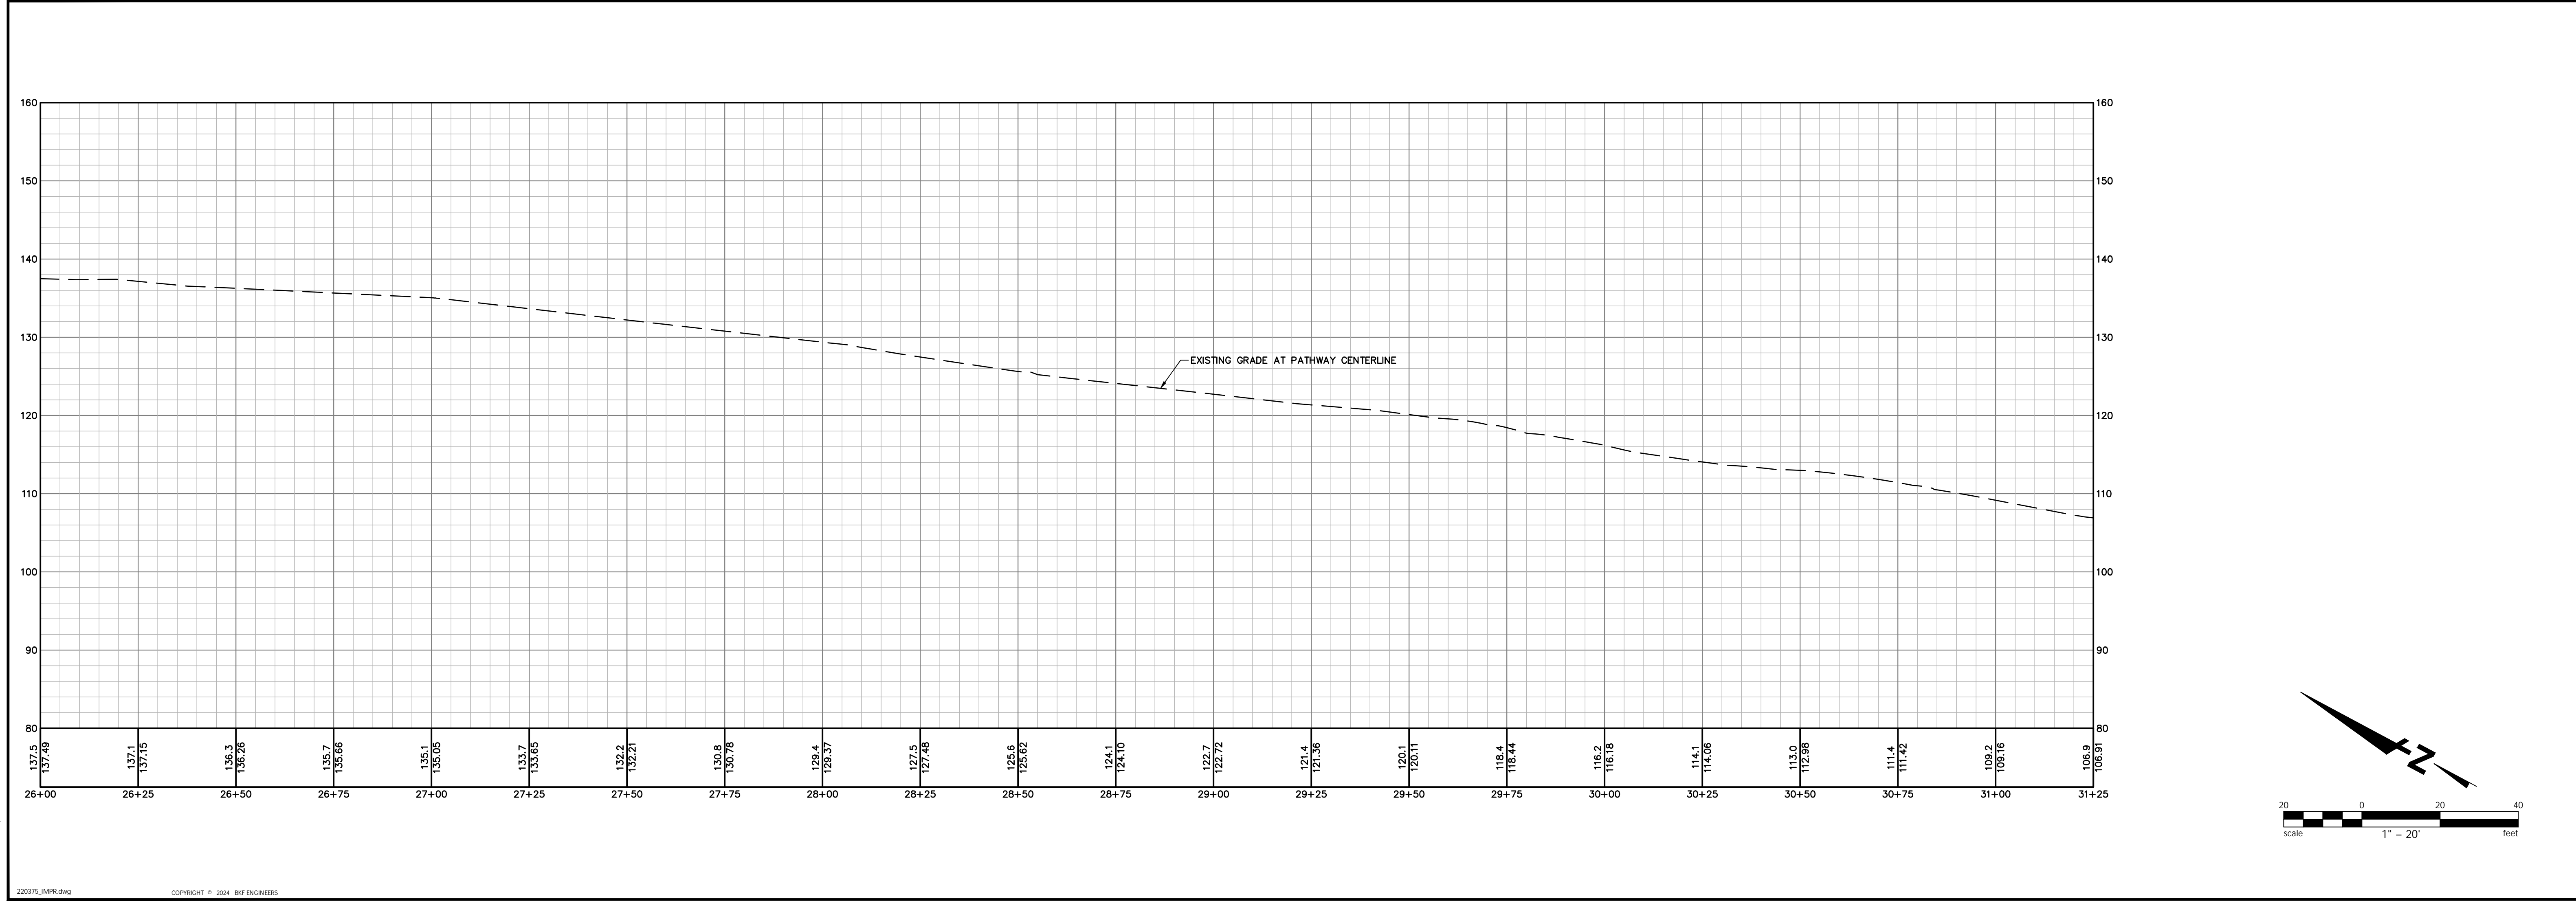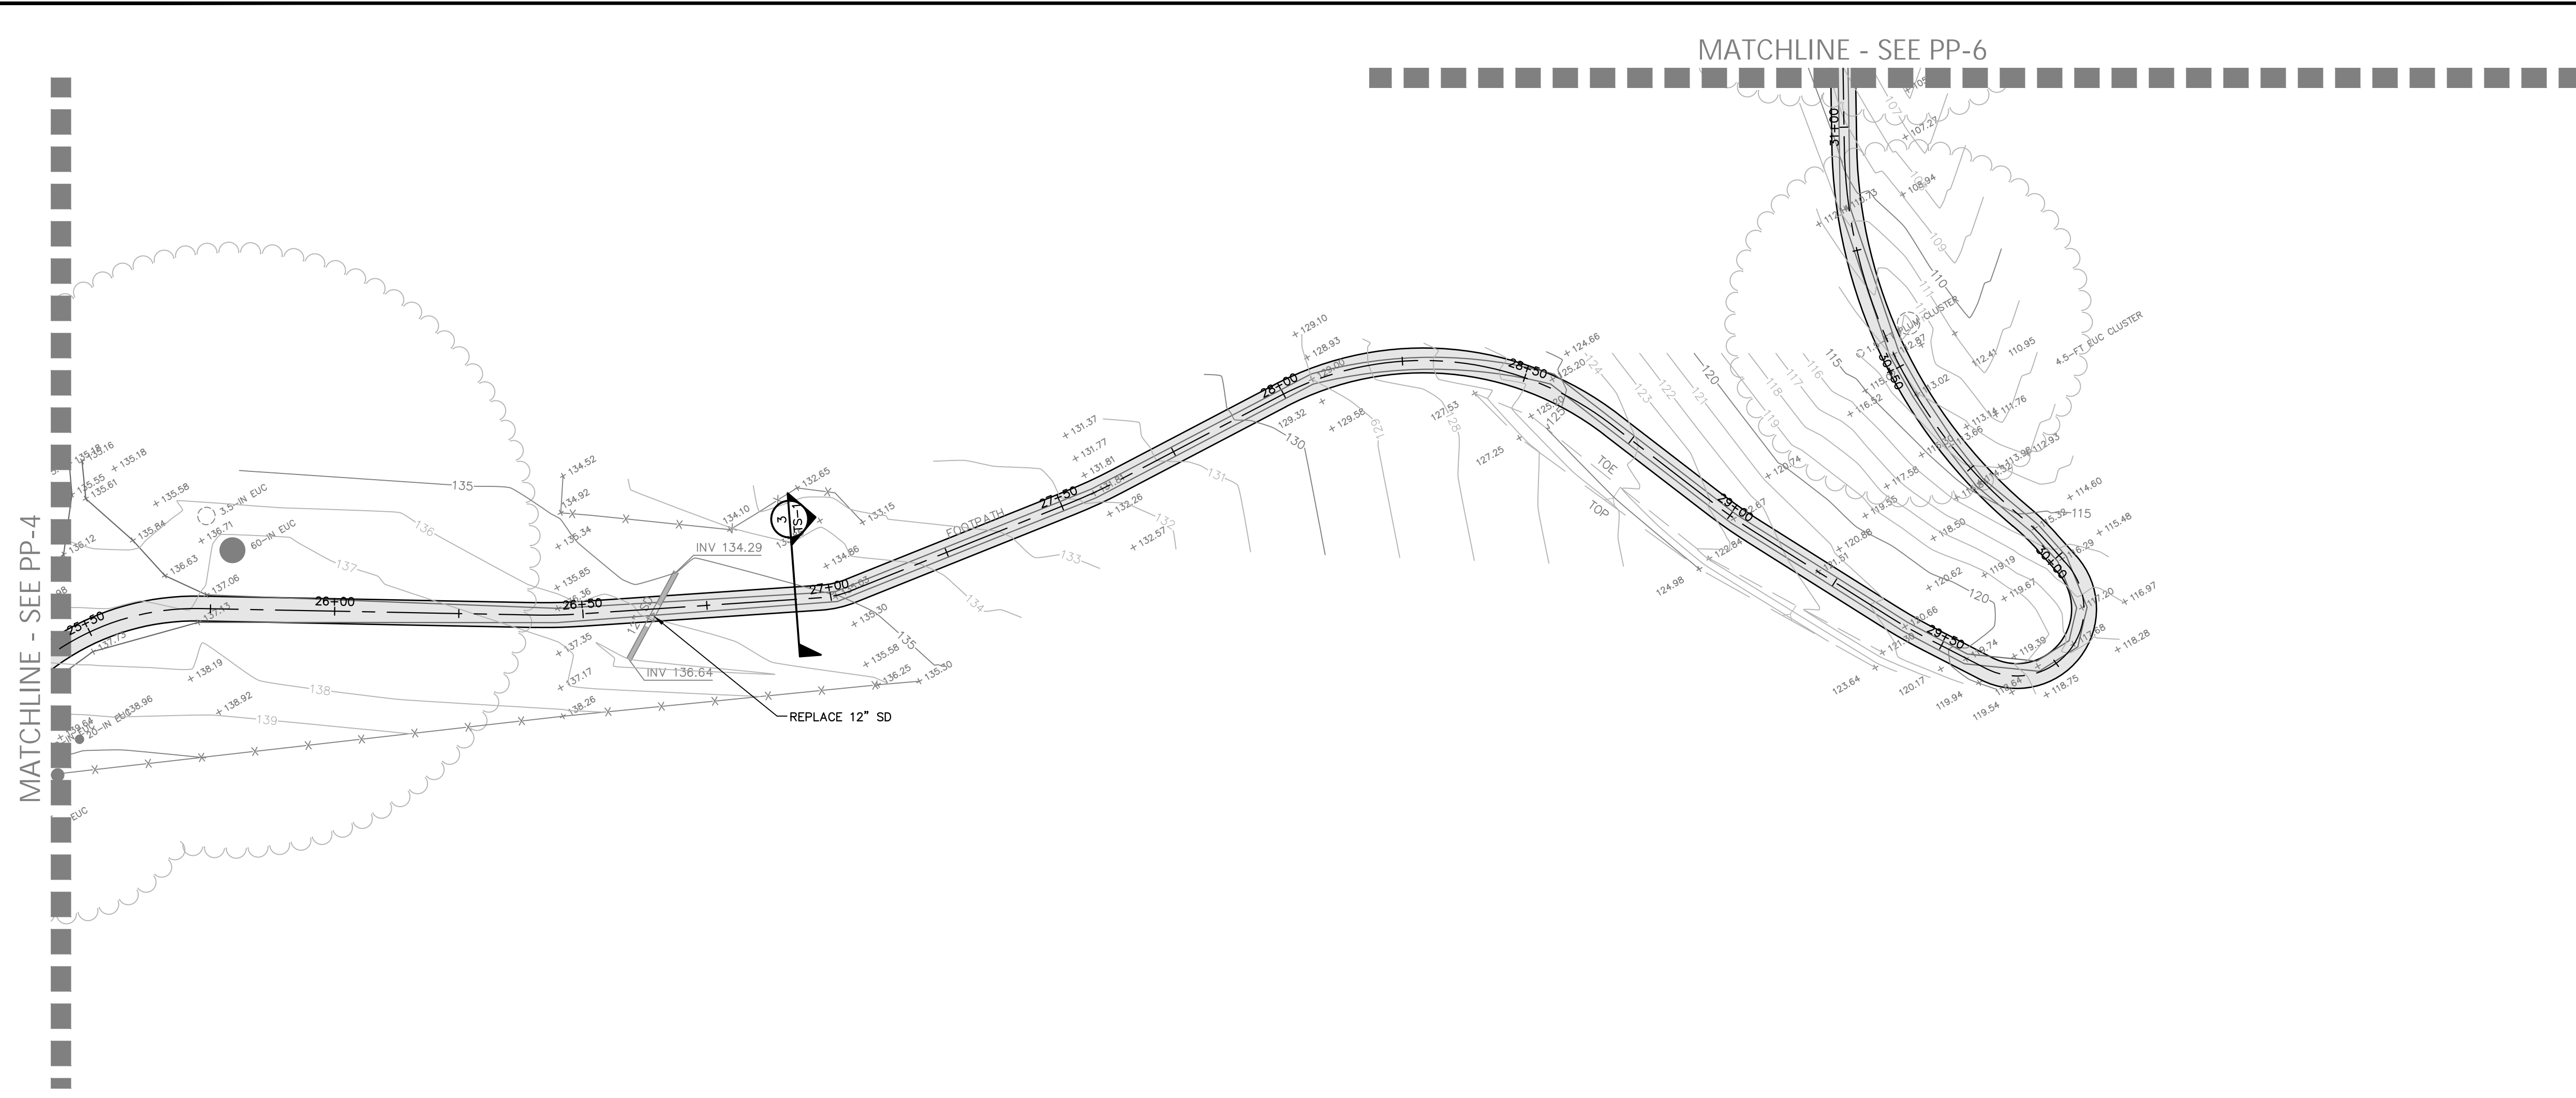

**PRELIMINARY**  
NOT FOR CONSTRUCTION  
DATE: 02/26/2024  
REBECCA DOWER  
C 80868

BKF ENGINEERS  
200 4th STREET  
SUITE 300  
SANTA ROSA, CA 95401  
(707) 583-8500  
www.bkf.com







**BOLINAS PATHWAY**  
APN 193-030-38  
MESA RD & OLEMA BOLINAS RD, BOLINAS, CA  
**PATHWAY PLAN & PROFILE**  
STA 26+00 TO STA 31+25

Revisions	
No.	

Date: FEB 2024  
Scale: AS SHOWN  
Design: IC  
Drawn: AS  
Approved: BD  
Job No: 20220375  
Drawing Number:  
**PP-5**  
7 OF 10


PP-5 26+00 TO 31+25.dwg



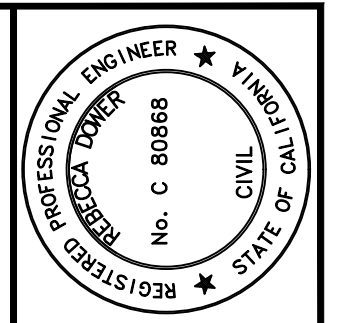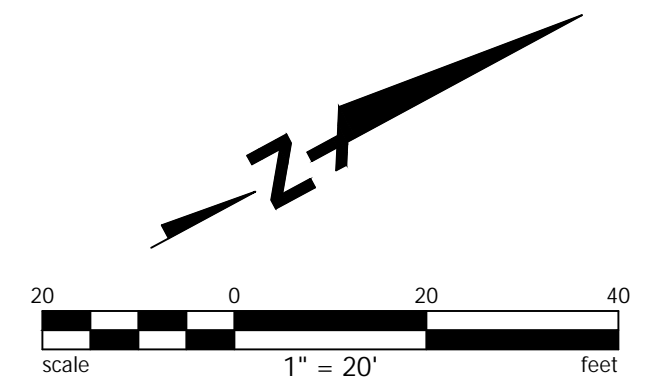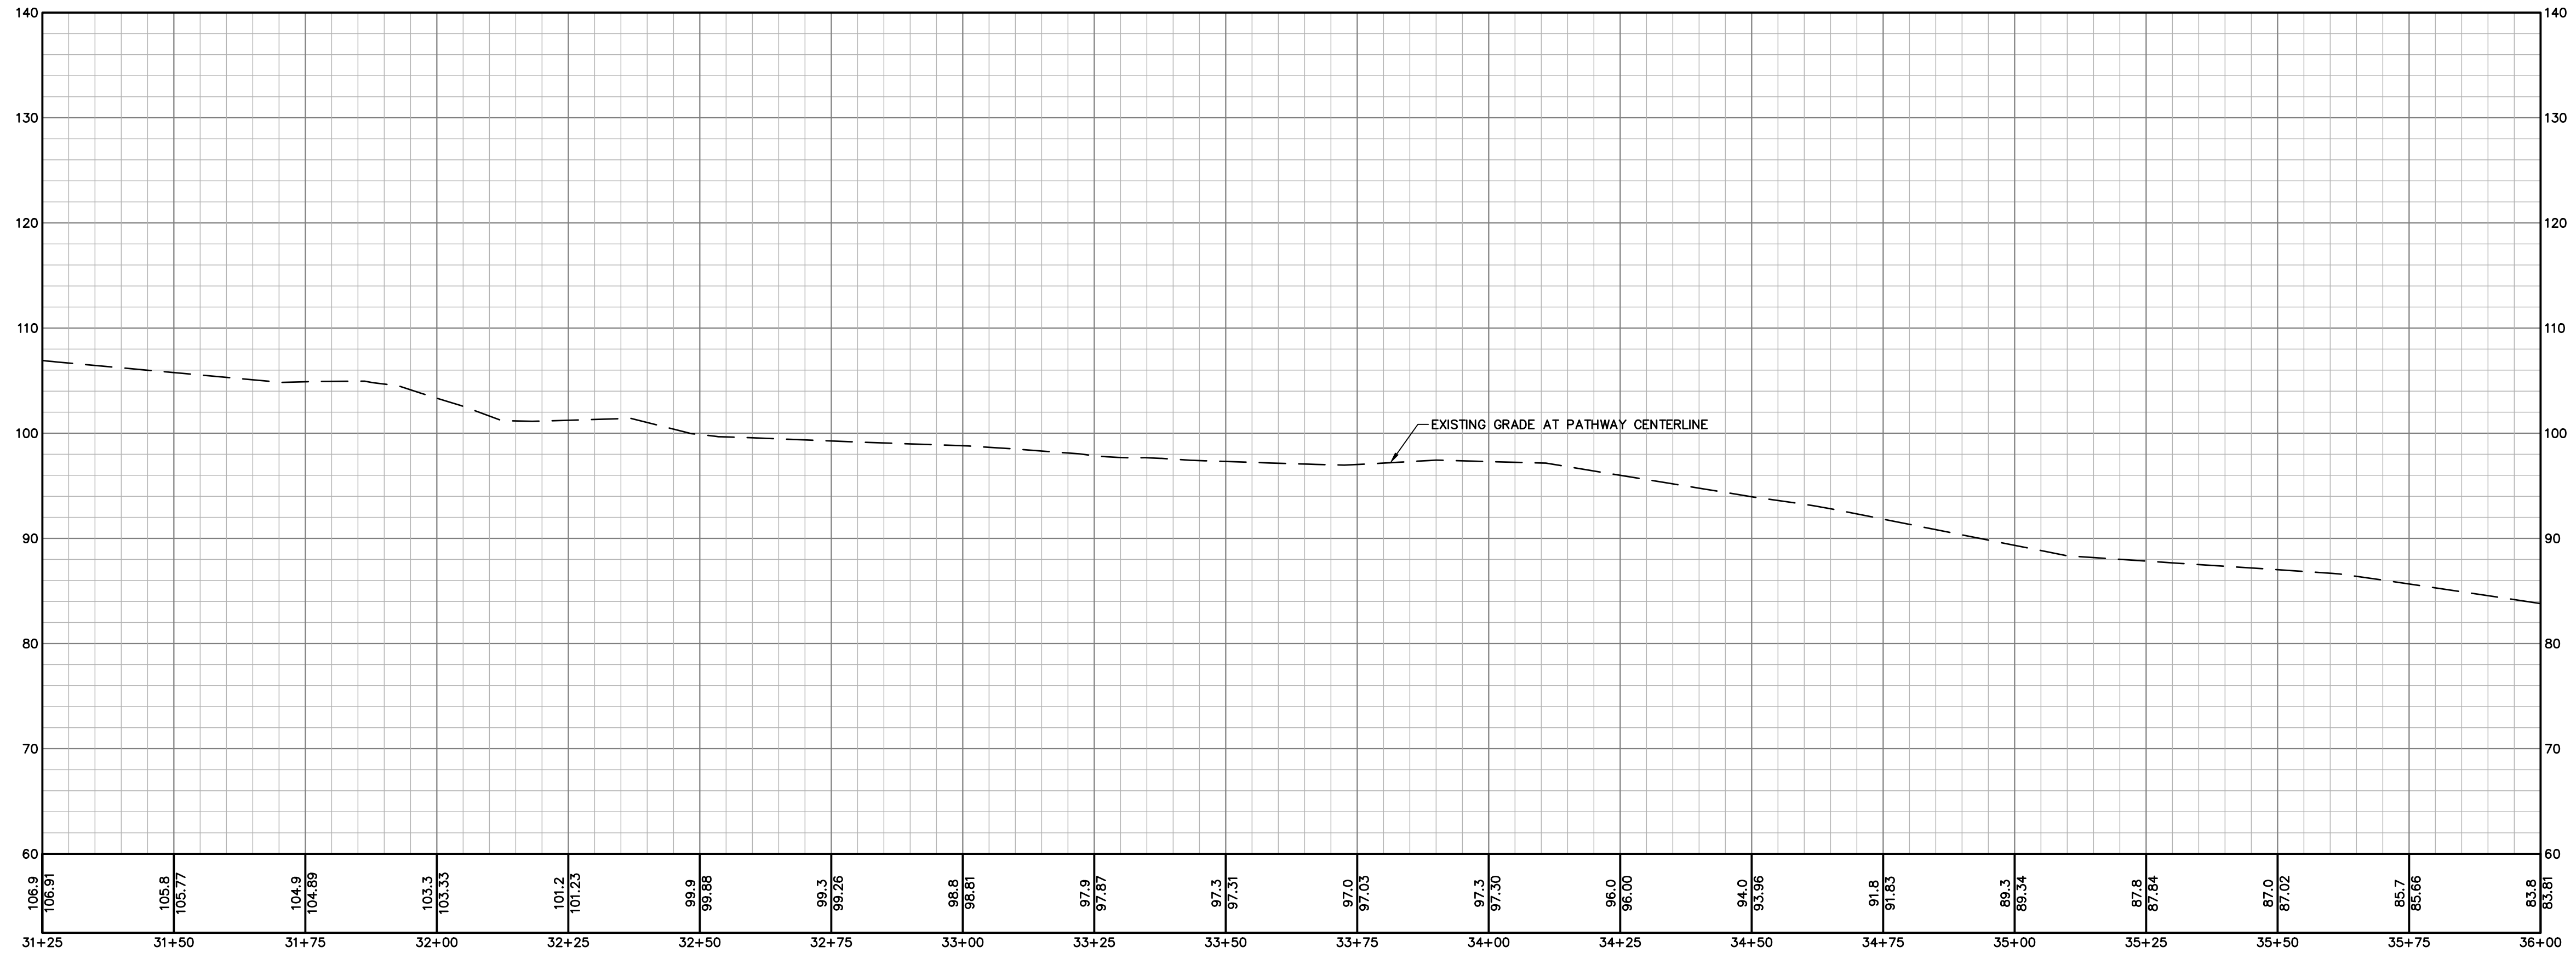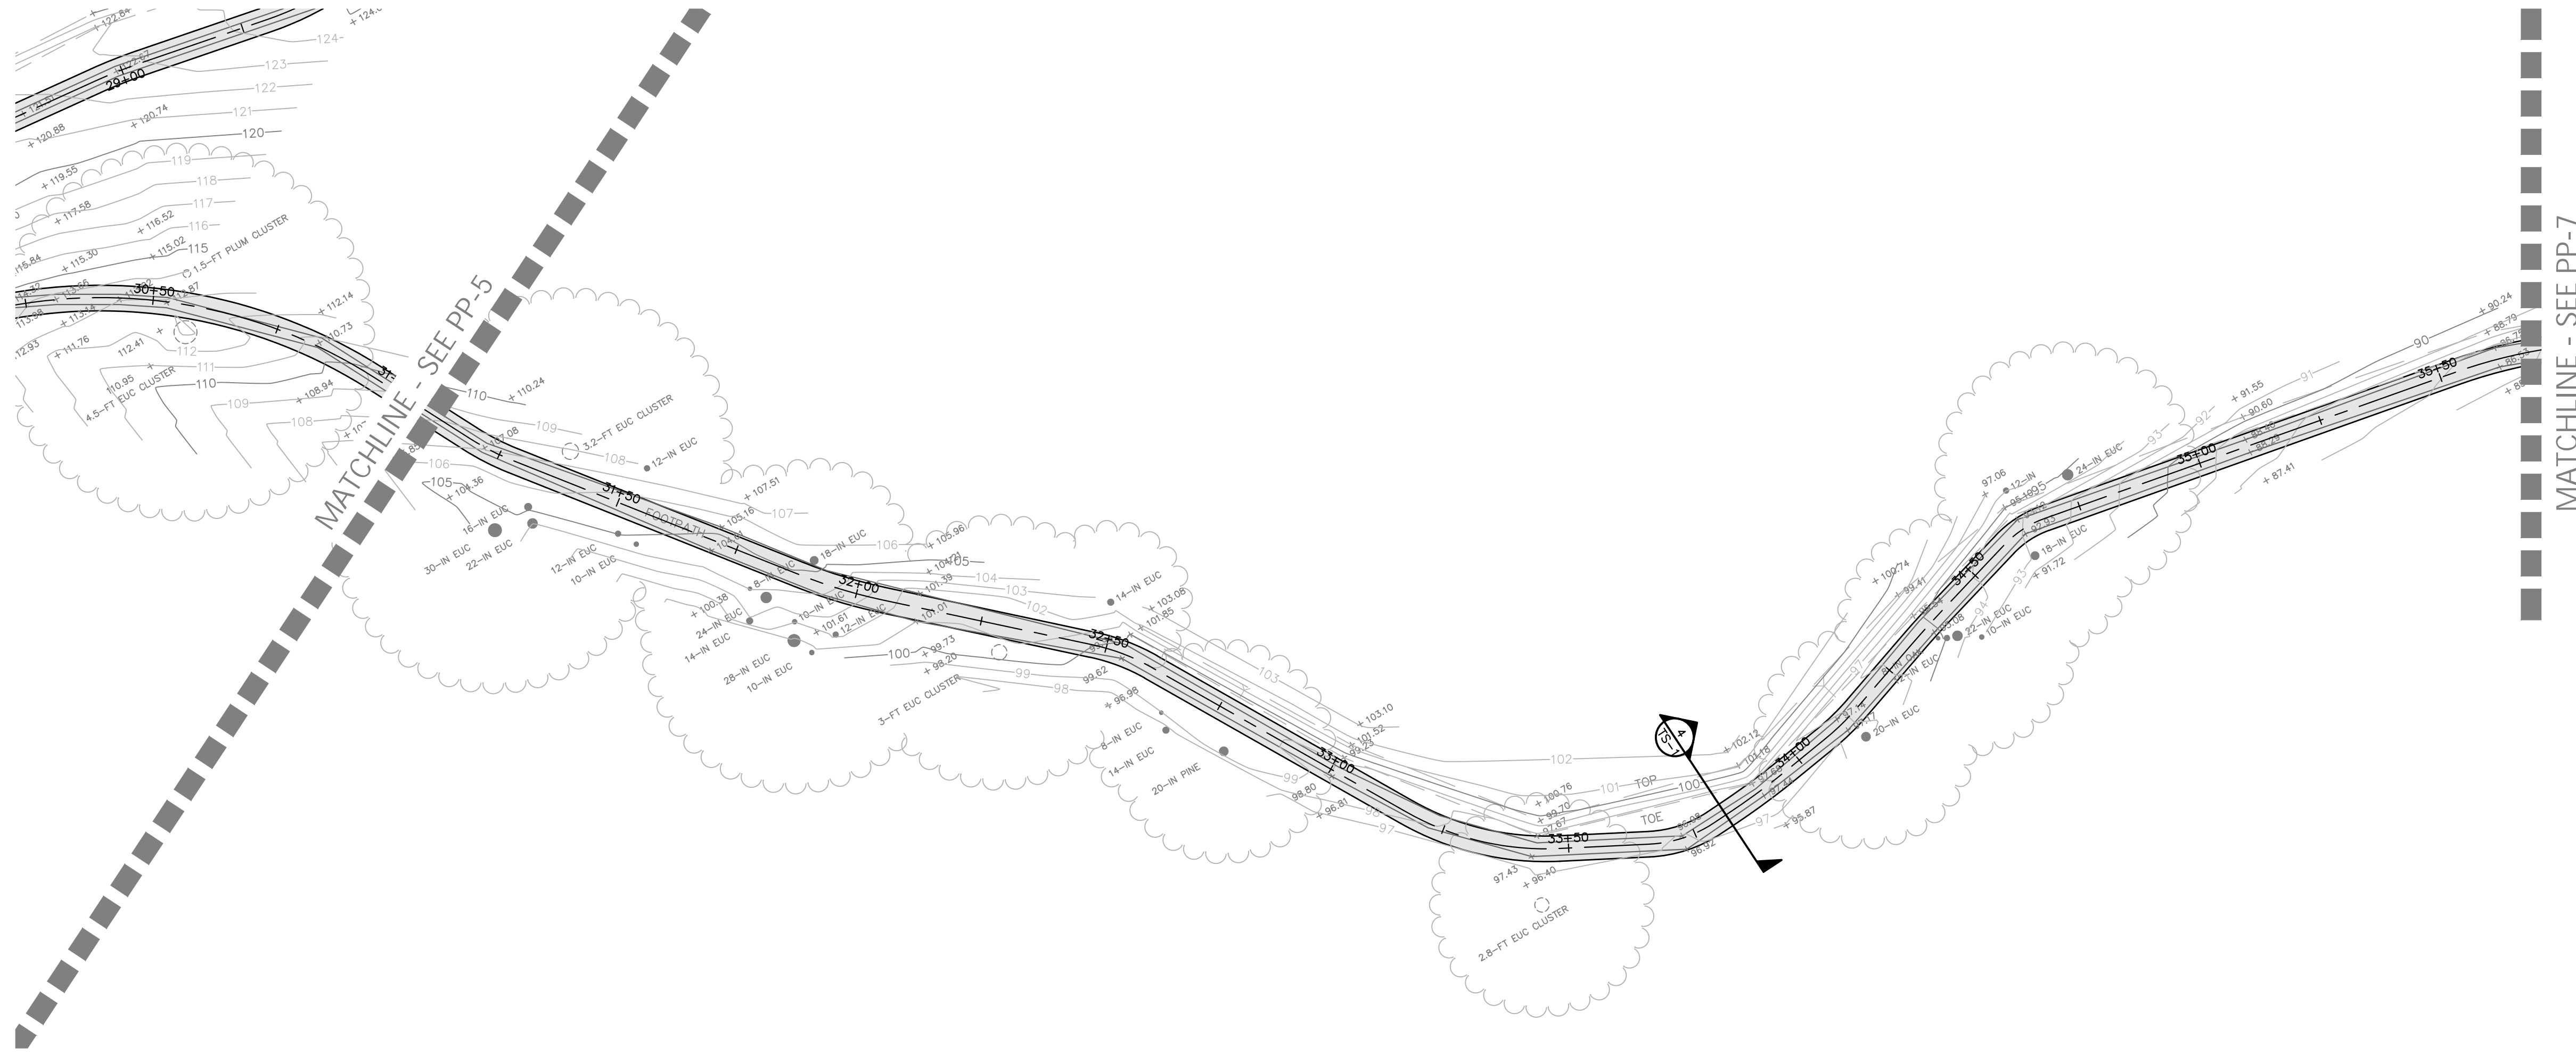

**PRELIMINARY**  
NOT FOR CONSTRUCTION  
DATE: 02/26/2024  
REBECCA DOWER

BKF ENGINEERS  
200 4TH STREET  
SANTA ROSA, CA 95401  
(707) 583-8500  
www.bkf.com

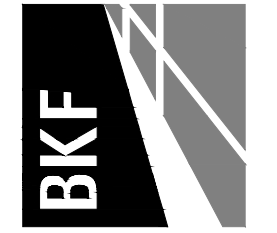




BOLINAS PATHWAY  
APN 193-030-38  
MESA RD & OLEMA BOLINAS RD, BOLINAS, CA  
**PATHWAY PLAN & PROFILE**  
STA 31+25 - STA 36+00

Revisions	
No.	Description

Date: FEB 2024  
Scale: AS SHOWN  
Design: IC  
Drawn: AS  
Approved: BD  
Job No: 20220375  
Drawing Number:  
**PP-6**  
8 OF 10


Proj: Feb 26, 2024, 11:45 AM  
220375\_IMPR.dwg  
COPYRIGHT © 2024, BKF ENGINEERS



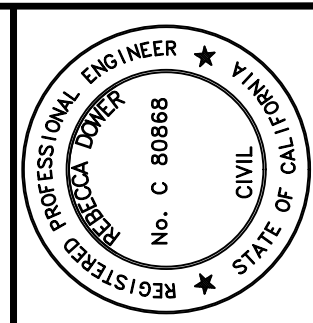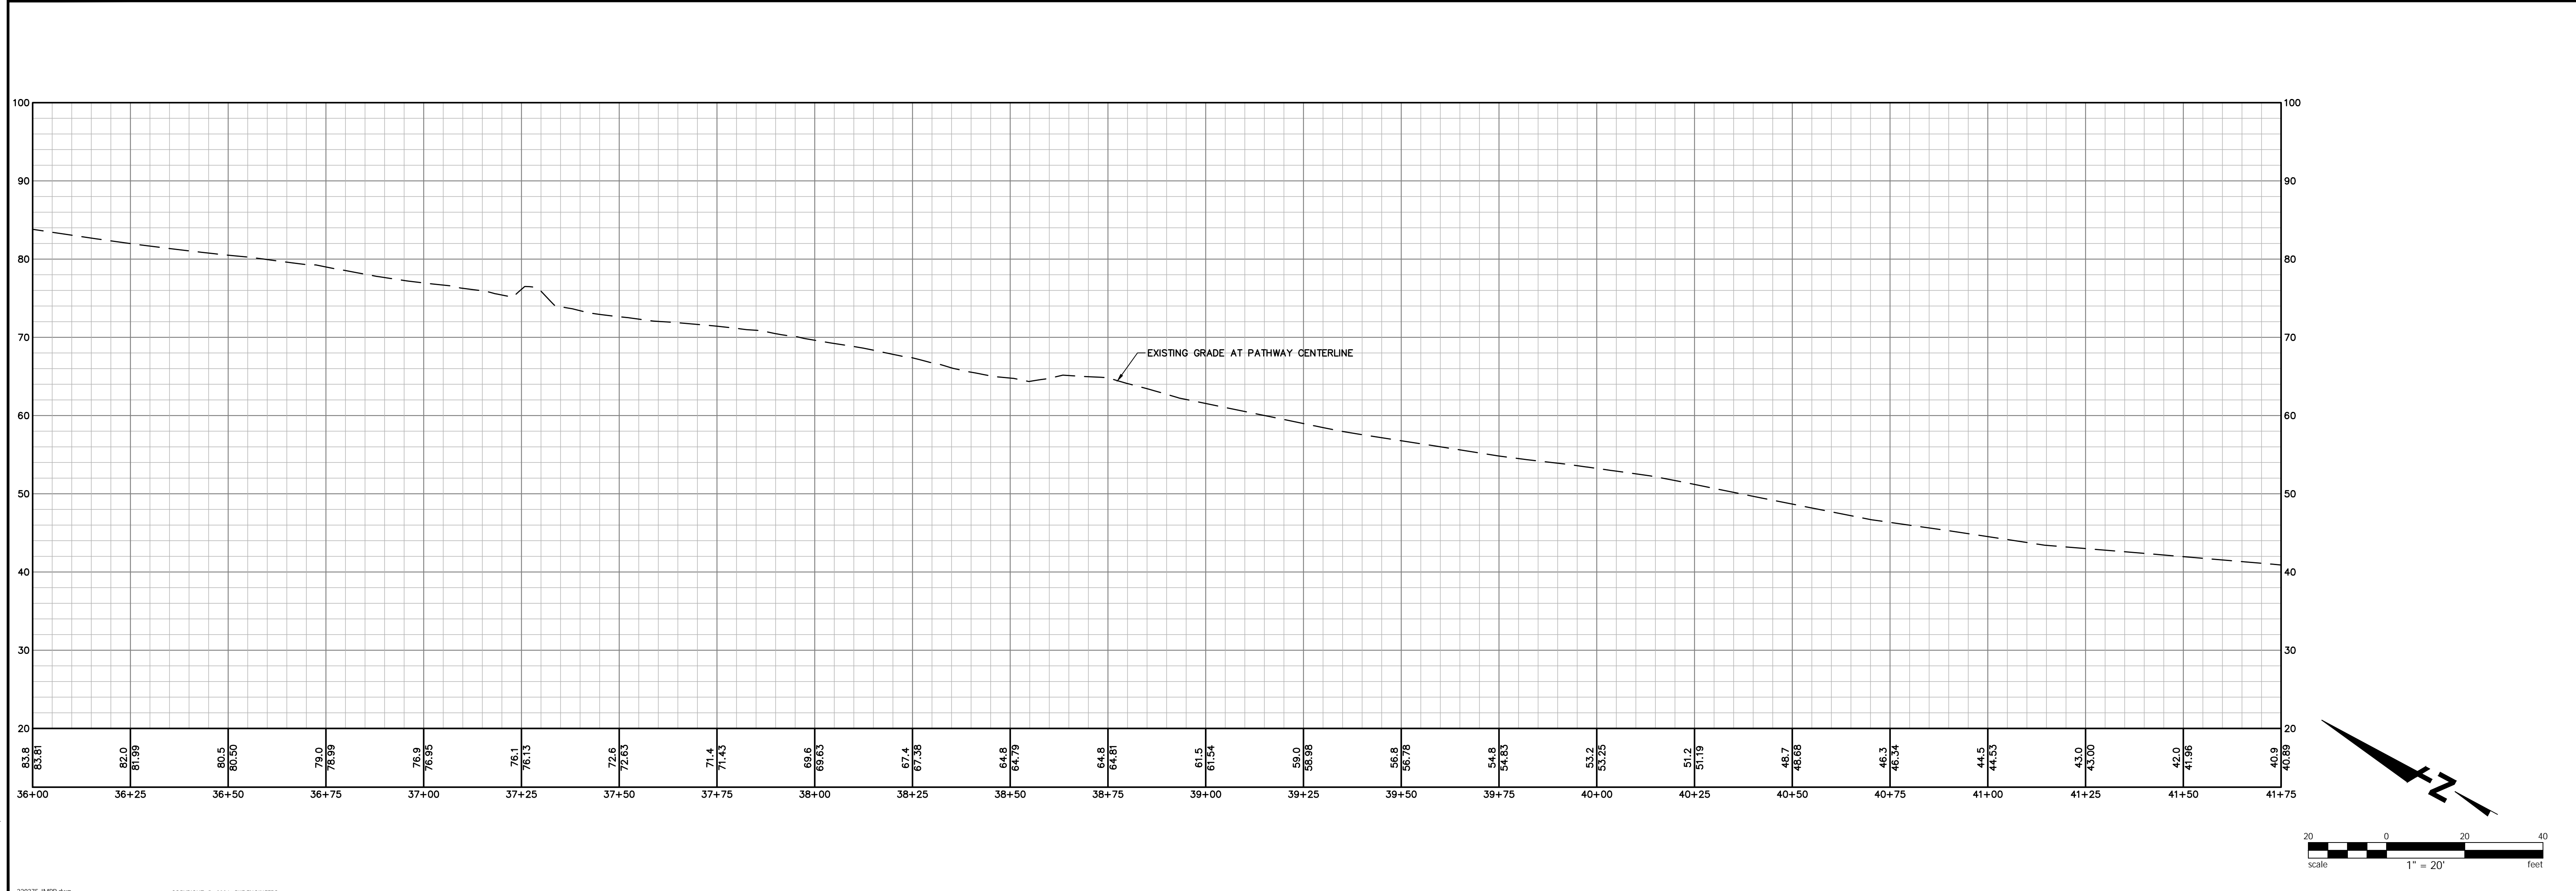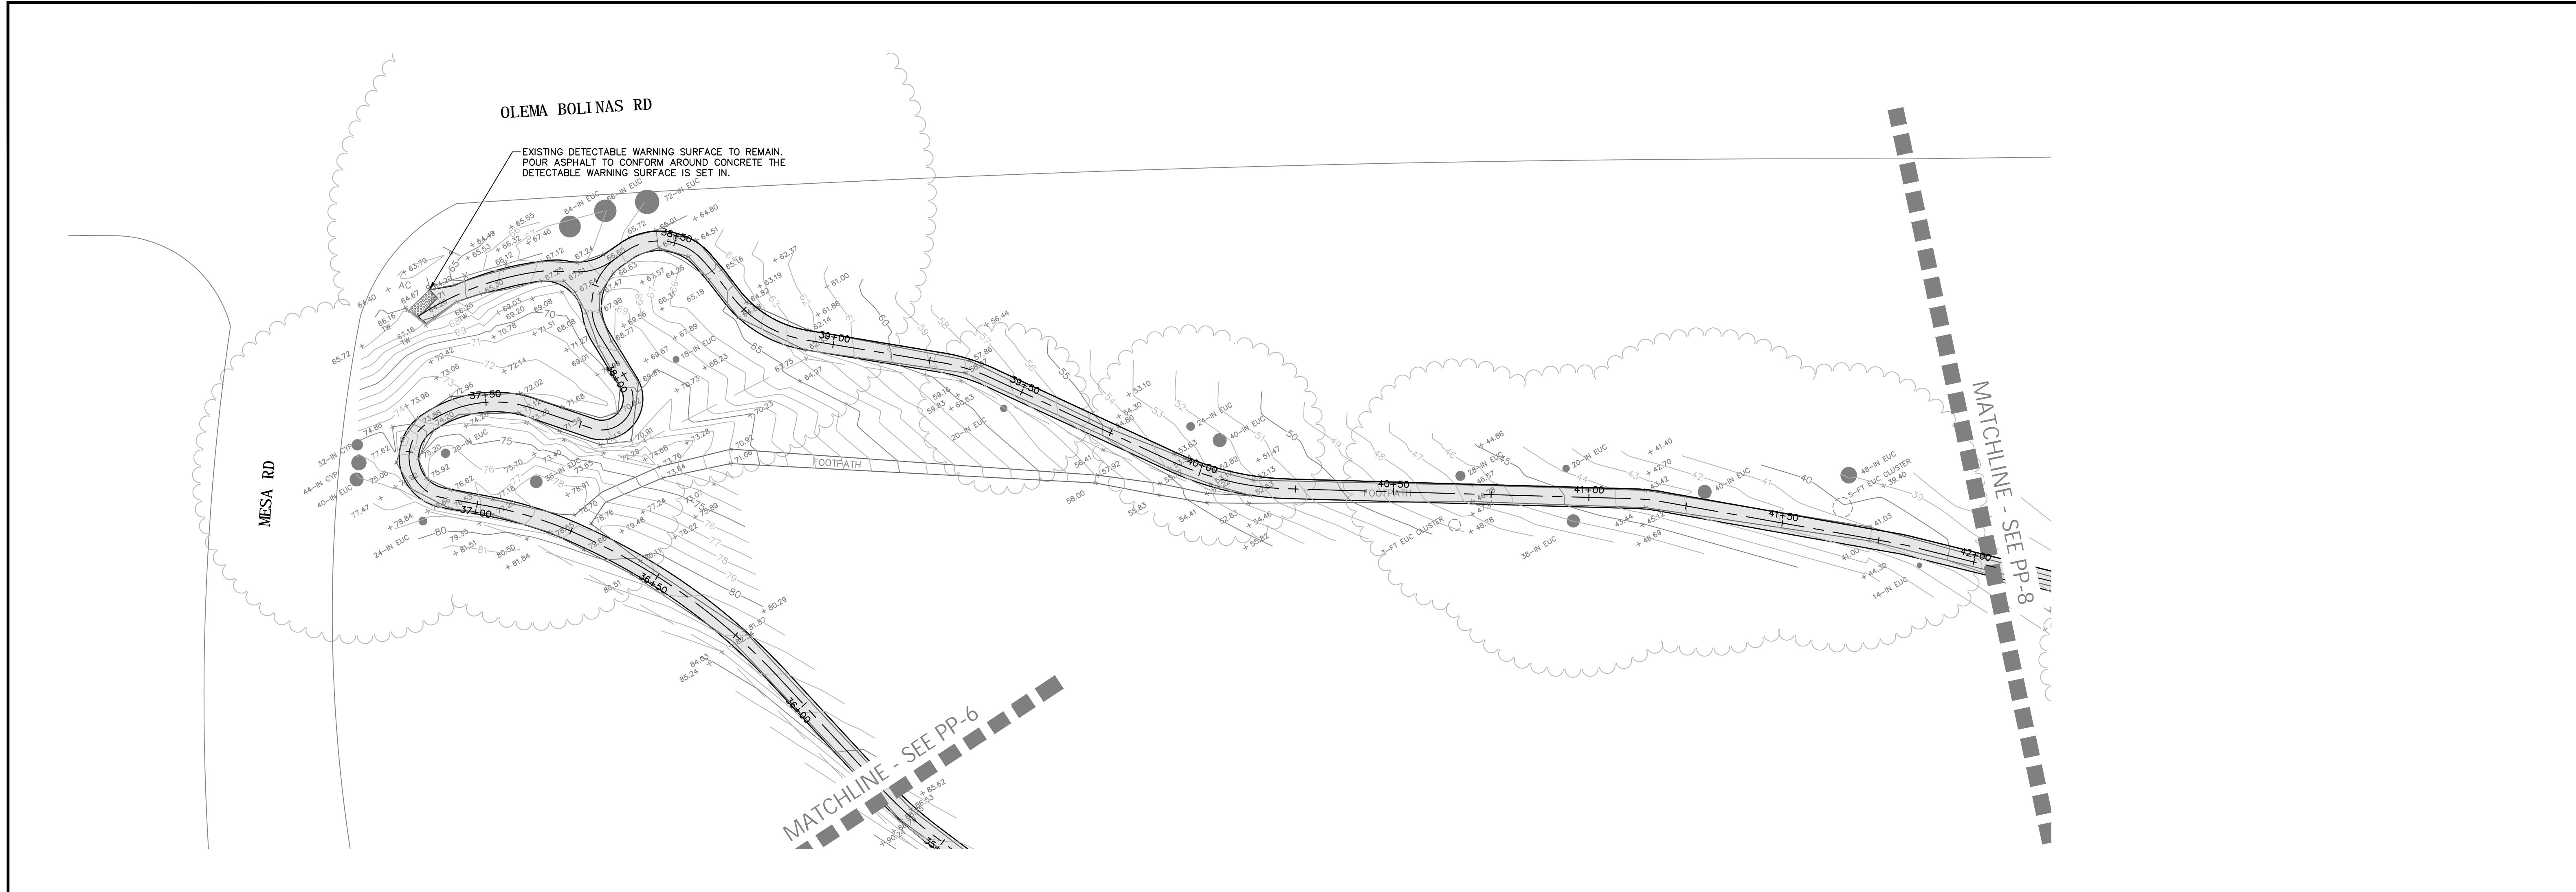

**PRELIMINARY**  
NOT FOR CONSTRUCTION  
DATE: 02/26/2024  
REBECCA DOWER  
C 80868

BKF ENGINEERS  
200 4th STREET  
SUITE 300  
SANTA ROSA, CA 95401  
(707) 583-8500  
www.bkf.com

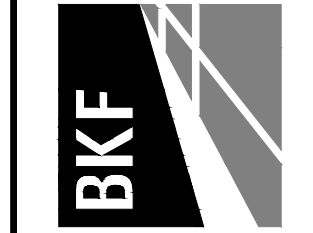

**BOLINAS PATHWAY**  
APN 193-030-38  
MESA RD & OLEMA BOLINAS RD, BOLINAS, CA  
**PATHWAY PLAN & PROFILE**  
STA 36+00 - STA 41+75

Revisions	
No.	Description

Date: FEB 2024	Scale: AS SHOWN
Design: IC	Drawn: AS
Approved: BD	Job No: 20220375

Drawing Number:  
**PP-7**  
9 OF 10

